


EXHIBIT A-1

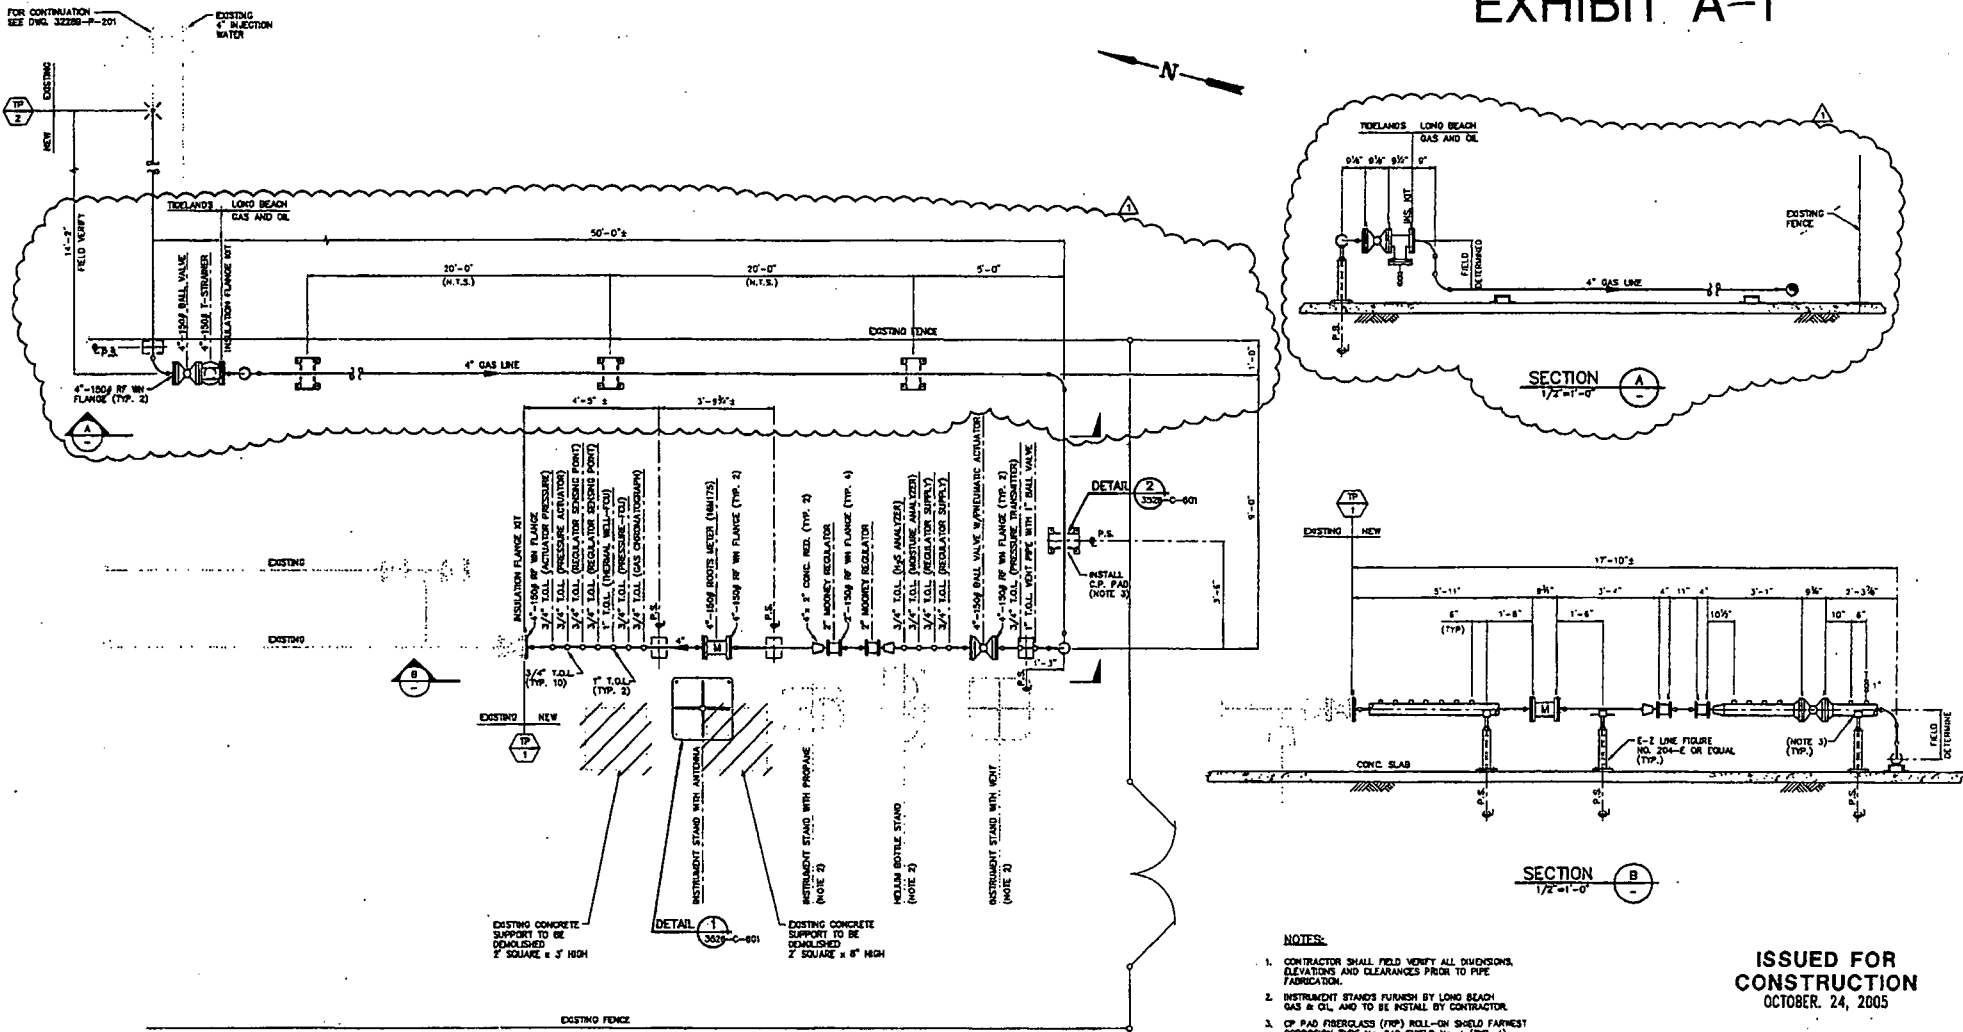

PIPING PLAN
FLOW CONTROL UNIT
SCALE: 1/2" = 1'-0"


1	11/29/05	MOVED 4" GAS LINE INSIDE THE FENCE	SAS	AB
0	10/24/05	ISSUED FOR CONSTRUCTION	R	AB



Tidelands
OIL PRODUCTION COMPANY

FLOW CONTROL UNIT
PROPOSED LAYOUT
PIPING PLAN AND SECTIONS

EXHIBIT A-2

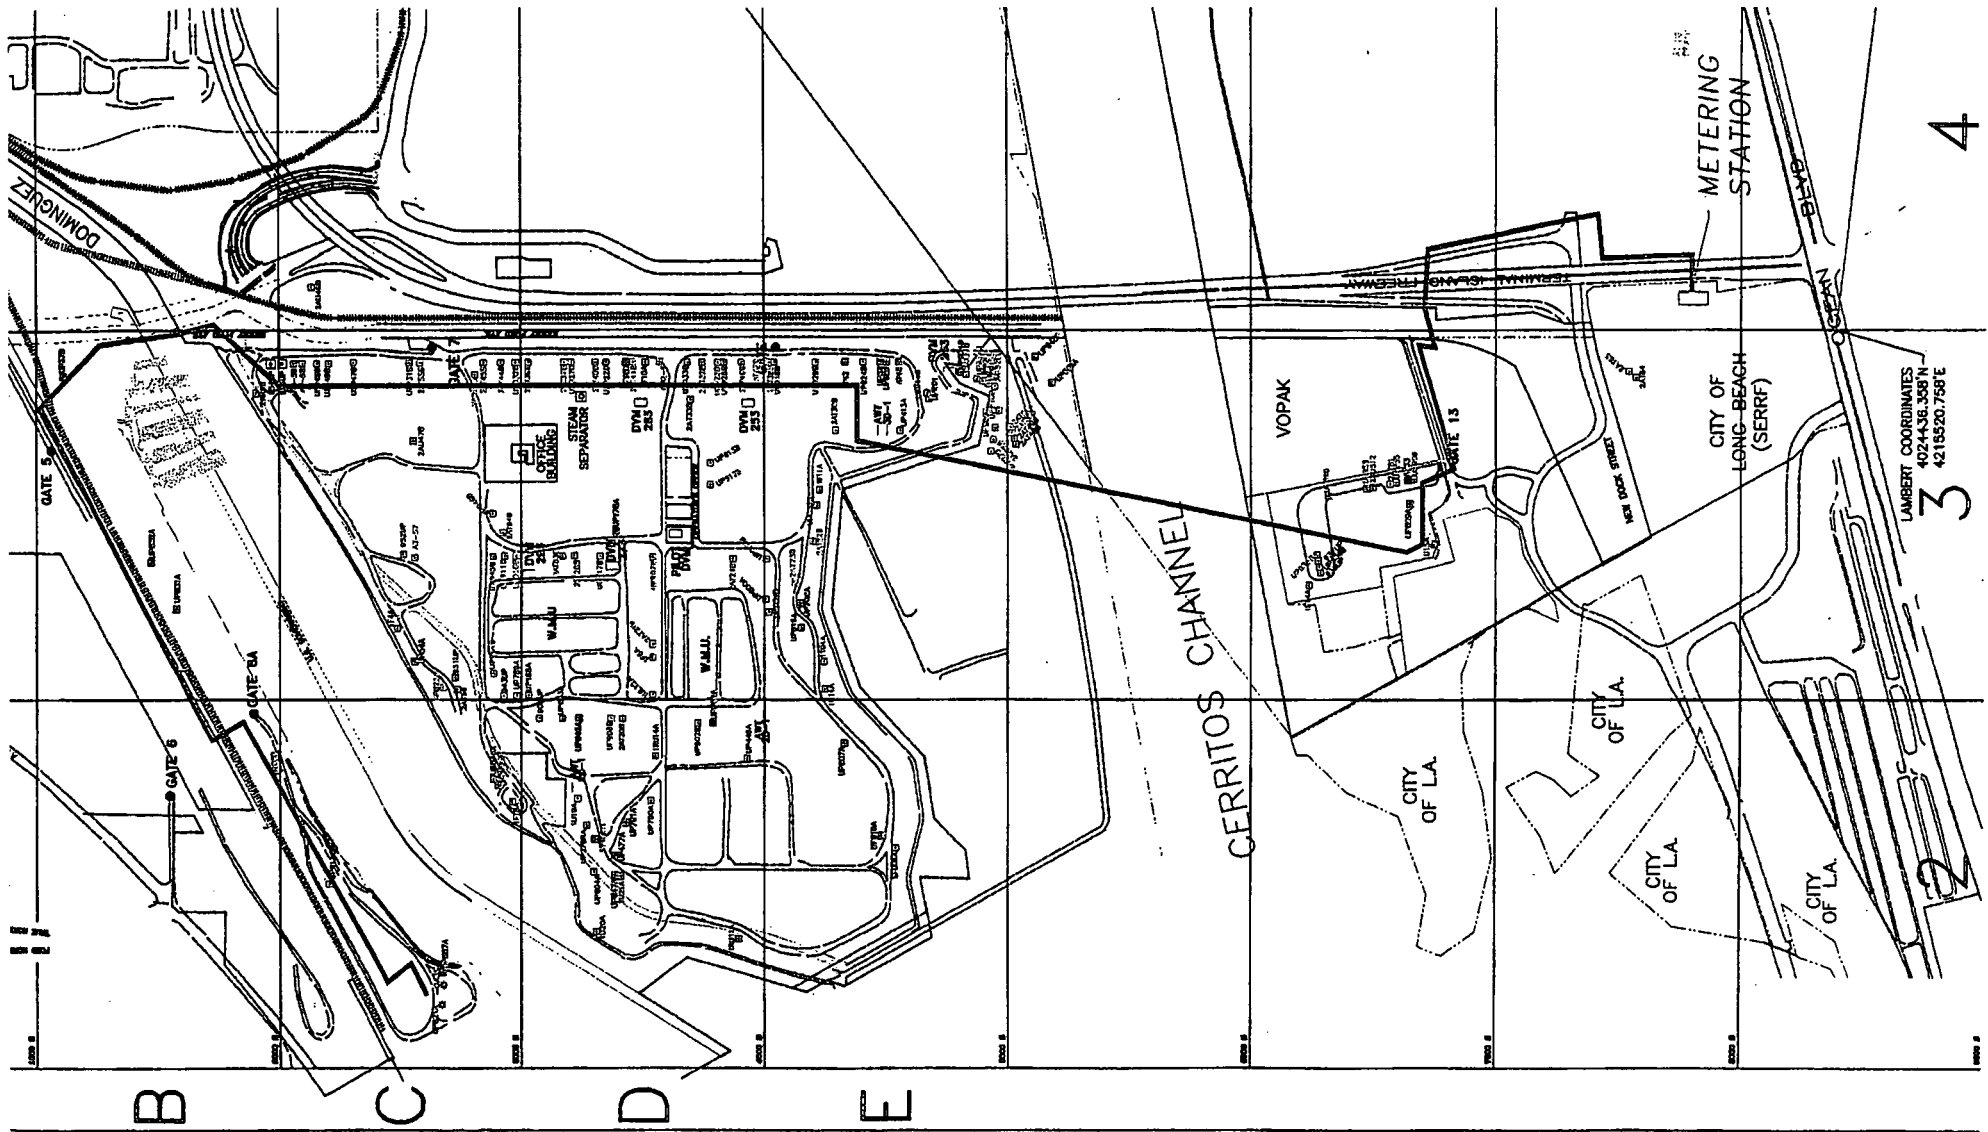

LAMBERT COORDINATES
40244.35.358 N
4218520.758 E

4
3
2