



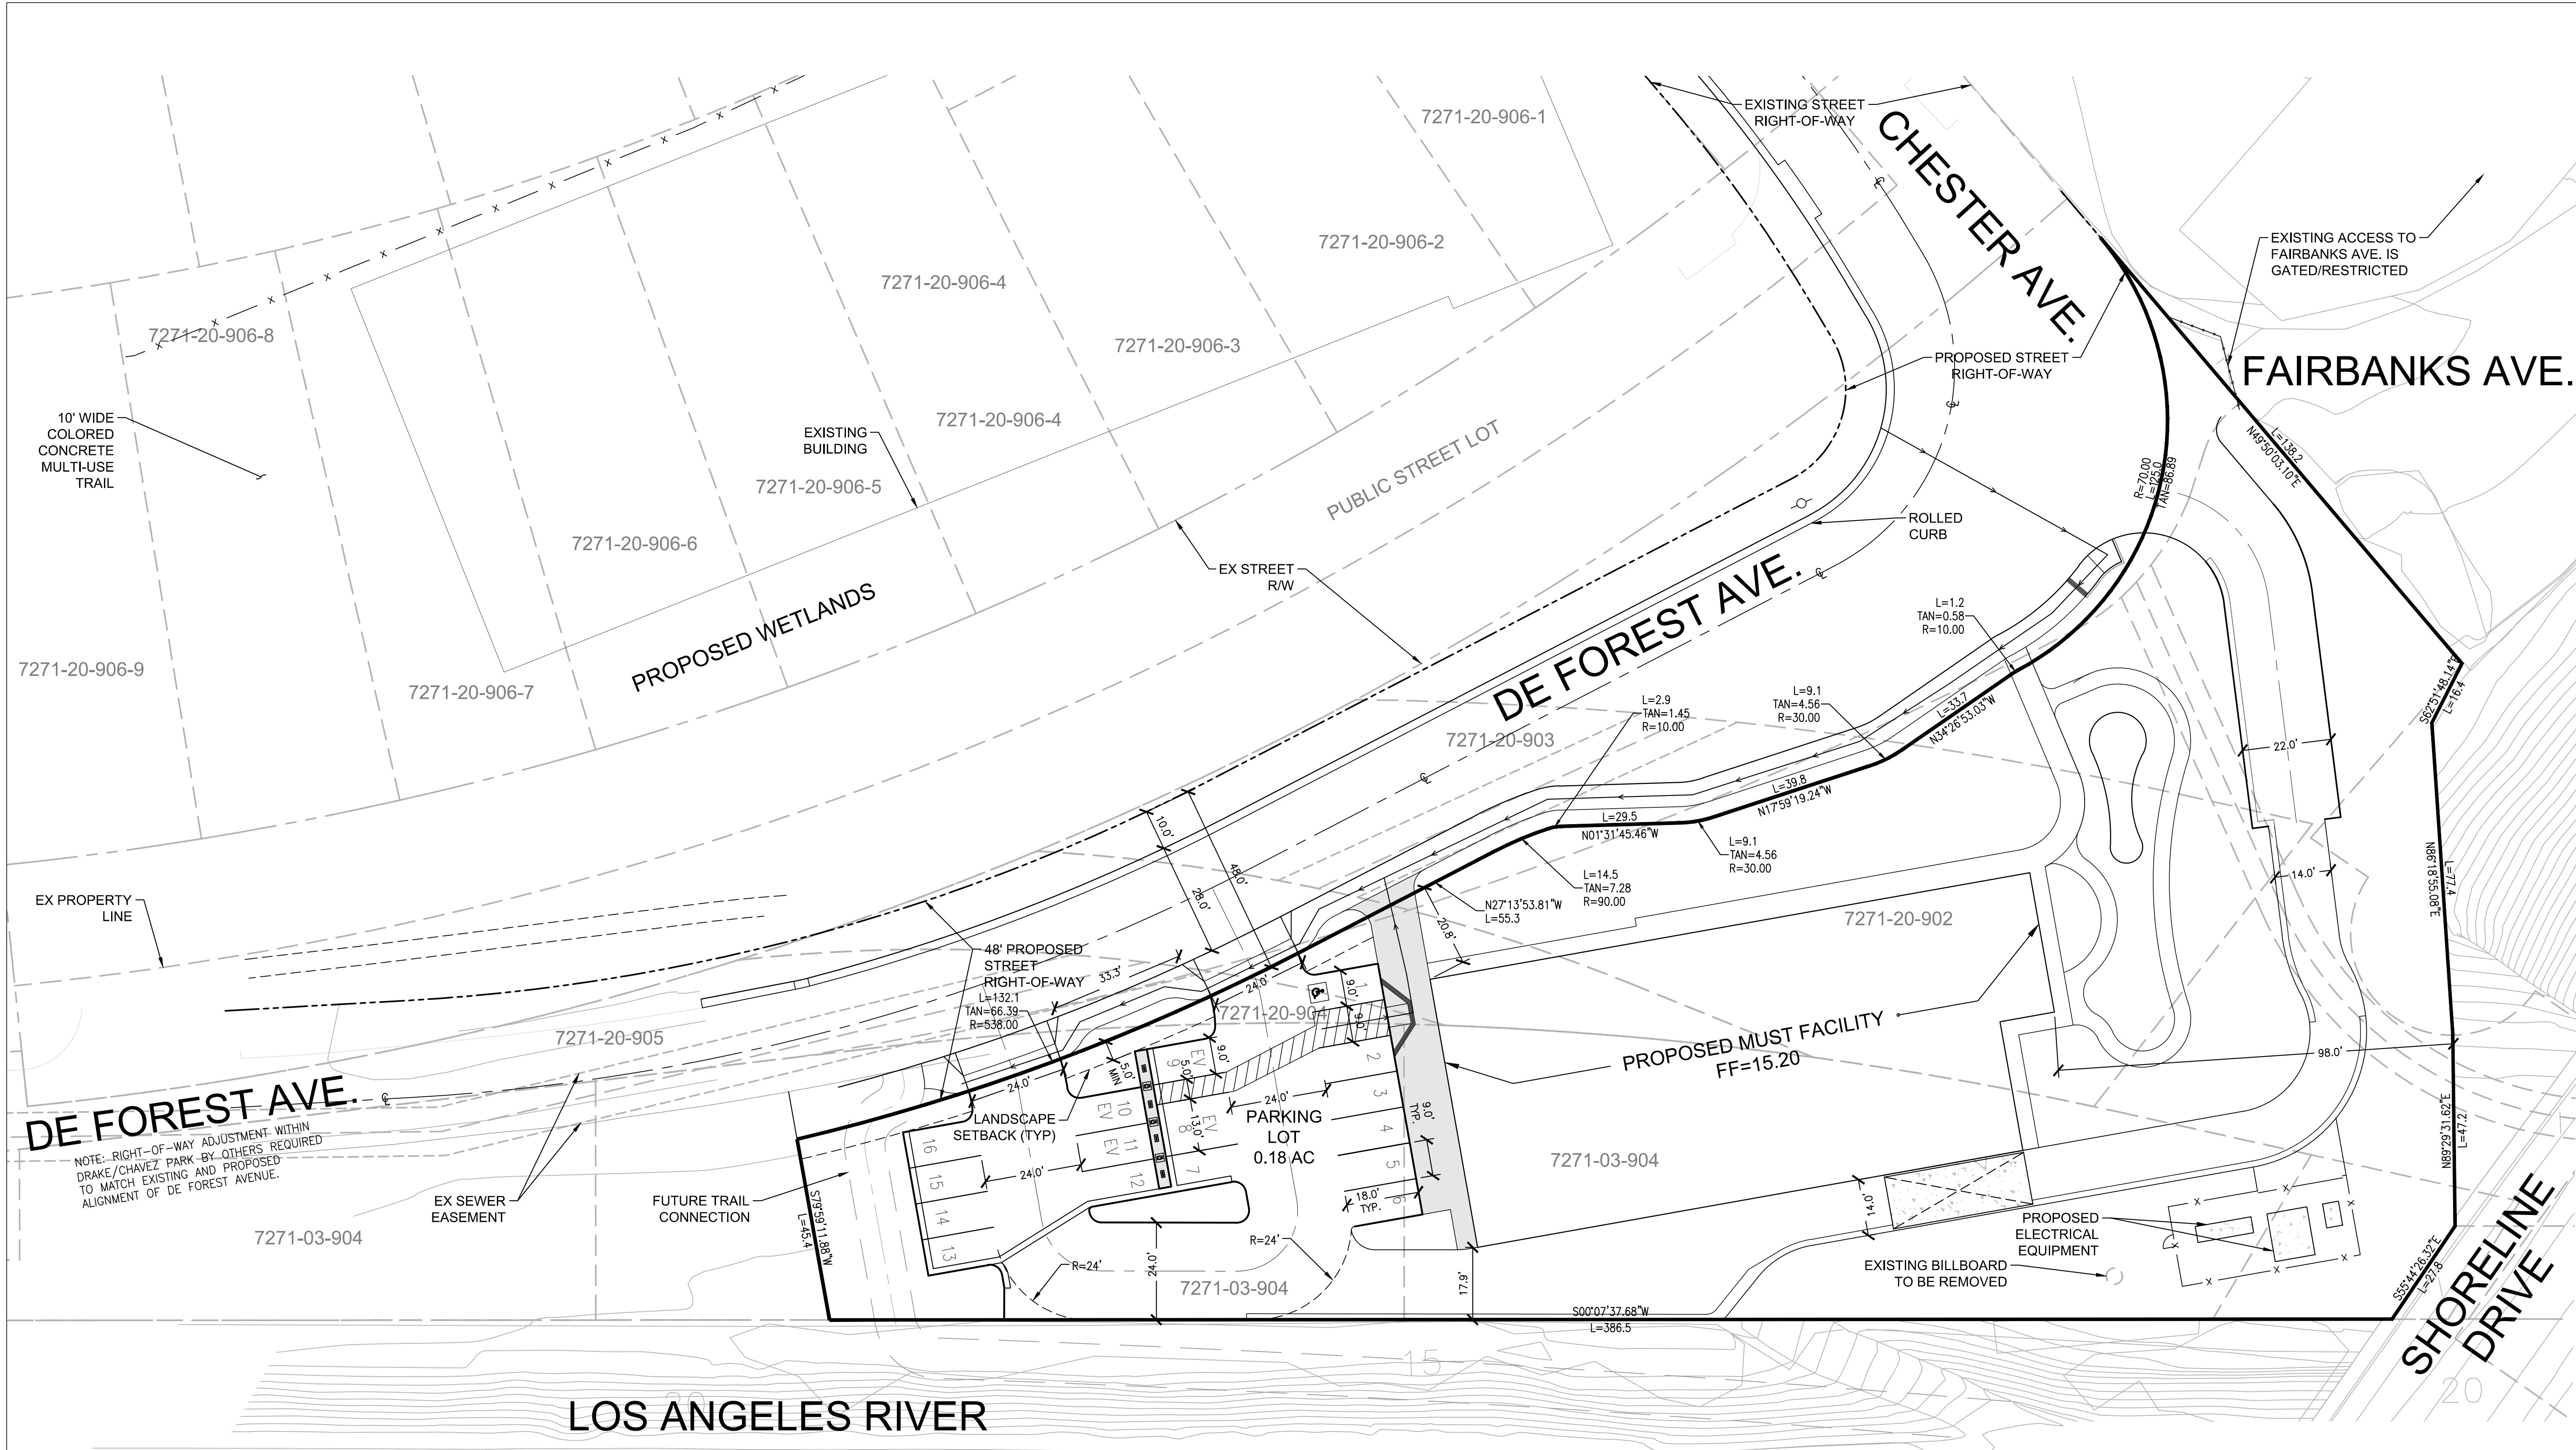

LAST SAVED BY: ejwalker  
PLOT DATE: Feb. 14, 19 SAVED PATH: C:\workdir\0447208

| LEGEND   |          |                           |
|----------|----------|---------------------------|
| EXISTING | PROPOSED | DESCRIPTION               |
|          | LOT 1    | LOT NUMBER/LETTER         |
|          |          | PROPOSED LOT BOUNDARY     |
|          |          | PROPERTY LINE             |
|          |          | RIGHT-OF-WAY              |
|          |          | CENTERLINE                |
|          |          | EASEMENT OR SETBACK       |
|          |          | ACCESSIBLE PATH OF TRAVEL |

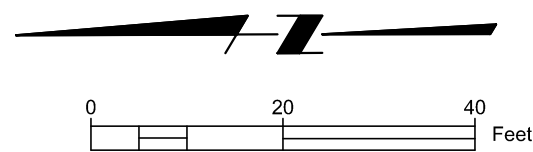

PRELIMINARY DESIGN PHASE - DATE SUBMITTED

NOT FOR CONSTRUCTION  
This document is an interim document and not suitable for construction. As an interim document, it may contain data that is potentially inaccurate or incomplete and is not to be relied upon without the express written consent of the preparer.



FN:01664C-EX7101A  
DATE: 12/28/18  
PLOT SCALE: 1=1


Long Beach Municipal Urban Stormwater Treatment  
TREATMENT PLANT AND WETLANDS  
SITE CONCEPT PLAN

JOB NO. PWXXXX XX  
NO. R- XXXX  
SHEET 1 OF 3  
DRAWING NO. EX-7101


| DESIGNED BY: |      | DRAWN BY: |  | DESIGN CHECK BY: |  | DRAFTING CHECK BY: |             |
|--------------|------|-----------|--|------------------|--|--------------------|-------------|
| EJW          |      | EJW       |  |                  |  |                    |             |
| REVISIONS    |      | APPROVAL  |  | SHEET            |  | AS-BUILT:          |             |
| No.          | DATE |           |  |                  |  |                    | REF. X-XXXX |
|              |      |           |  |                  |  |                    |             |
|              |      |           |  |                  |  |                    |             |
|              |      |           |  |                  |  |                    |             |
|              |      |           |  |                  |  |                    |             |



LAST SAVED BY: ejwalker  
PLOT DATE: Feb. 14, 19 SAVED PATH: C:\pworkdir\0446979

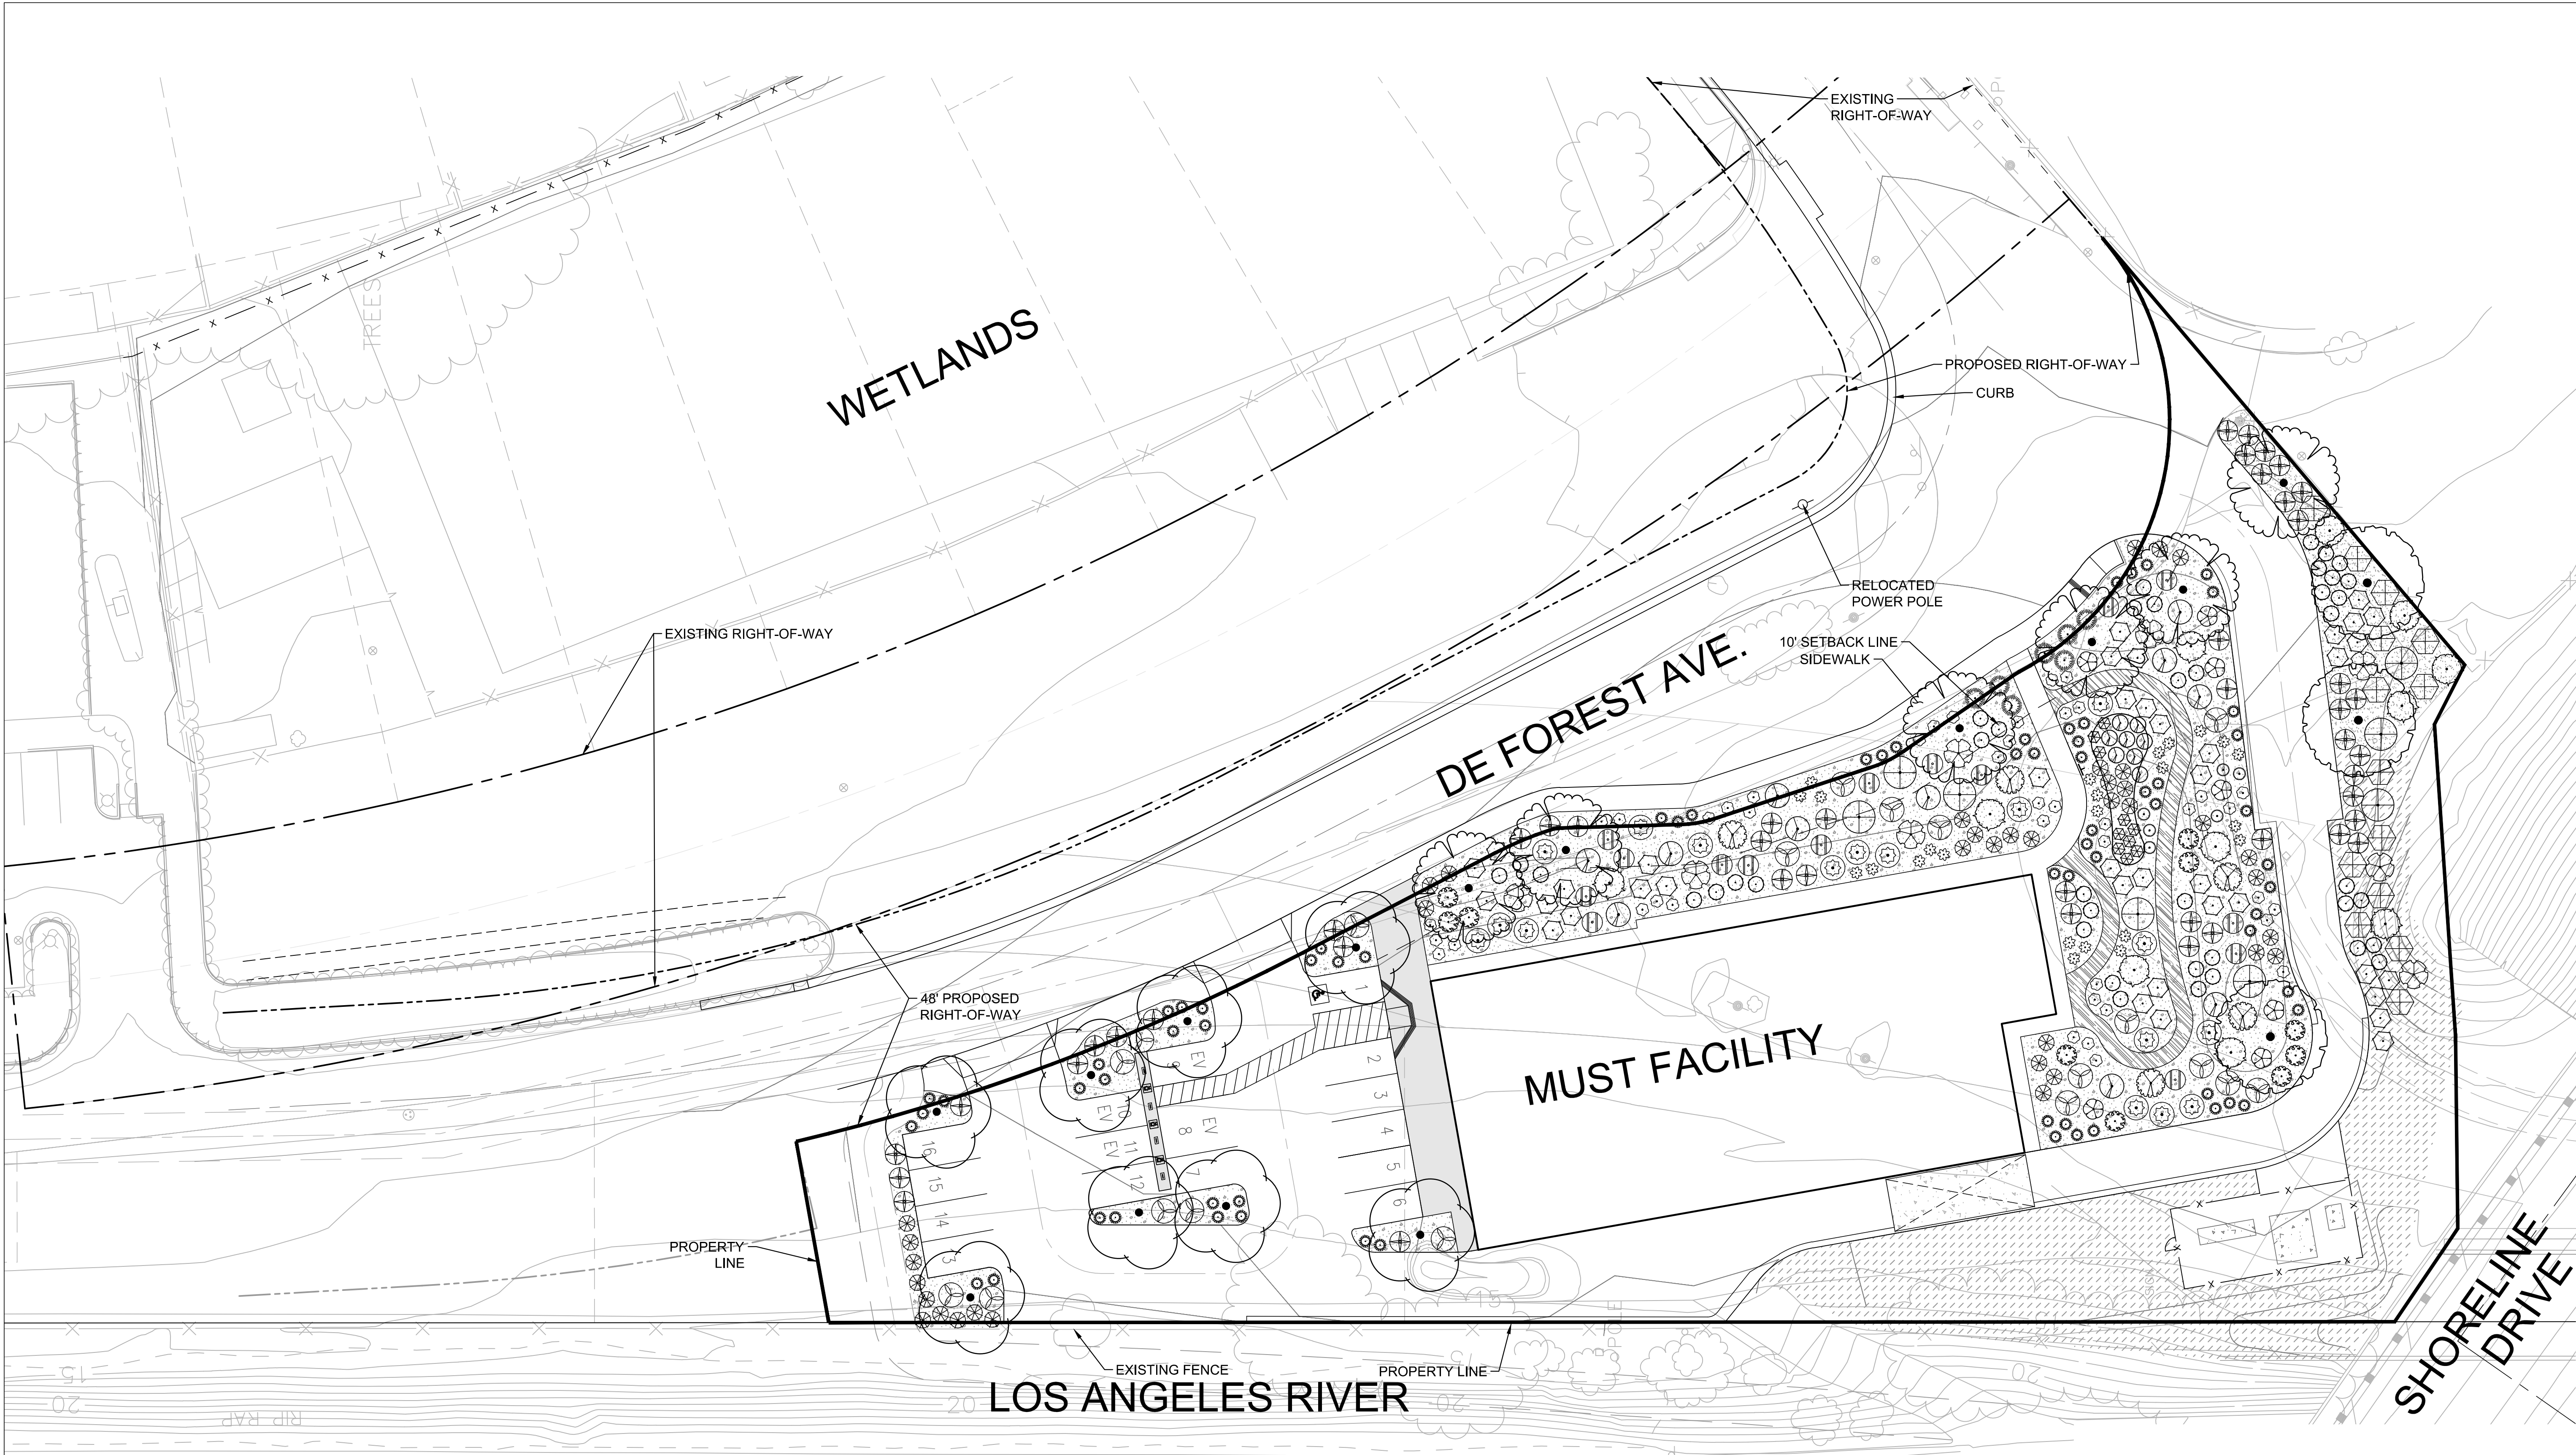

 NOTE:  
FOR LANDSCAPE ELEMENTS SCHEDULE SEE SHEET 3.



PRELIMINARY DESIGN PHASE - DATE SUBMITTED

NOT FOR CONSTRUCTION

This document is an interim document and not suitable for construction. As an interim document, it may contain data that is potentially inaccurate or incomplete and is not to be relied upon without the express written consent of the preparer.



FN:01664L-1012LC  
DATE: 12/21/18  
PLOT SCALE: 1=1

|                    |  |  |  |  |  |  |  |  |  |           |  |      |  |             |  |             |  |       |  |
|--------------------|--|--|--|--|--|--|--|--|--|-----------|--|------|--|-------------|--|-------------|--|-------|--|
| DESIGNED BY:       |  |  |  |  |  |  |  |  |  | REVISIONS |  |      |  | APPROVAL    |  | DESCRIPTION |  |       |  |
| DRAWN BY:          |  |  |  |  |  |  |  |  |  | No.       |  | DATE |  |             |  |             |  | SHEET |  |
| DESIGN CHECK BY:   |  |  |  |  |  |  |  |  |  |           |  |      |  |             |  |             |  |       |  |
| DRAFTING CHECK BY: |  |  |  |  |  |  |  |  |  |           |  |      |  |             |  |             |  |       |  |
|                    |  |  |  |  |  |  |  |  |  | AS-BUILT: |  |      |  | REF. X-XXXX |  |             |  |       |  |
|                    |  |  |  |  |  |  |  |  |  |           |  |      |  |             |  |             |  |       |  |

Long Beach Municipal Urban Stormwater Treatment

LANDSCAPE CONCEPT

FIELD BOOK  
X.X.X.

PAGE  
X.X.X.

GRAPHIC  
SCALE  






|                     |
|---------------------|
| JOB NO. PWXXXX XX   |
| NO. R- XXXX         |
| SHEET<br>2 OF 3     |
| DRAWING NO.<br>LC-1 |

LAST SAVED BY: ejwalker  
PLOT DATE: Feb. 14, 19 SAVED PATH: C:\pwworkdir\0446979

REFERENCE NOTES SCHEDULE

| CODE  | 01_EXISTING_ELEMENTS<br>DESCRIPTION                                                                                                                                                                        | QTY |
|-------|------------------------------------------------------------------------------------------------------------------------------------------------------------------------------------------------------------|-----|
| 01-01 | EXISTING BIOSWALE & HISTORICAL RAILROAD TRACKS, PROTECT IN PLACE.                                                                                                                                          |     |
| CODE  | 02_NEW_CONSTRUCTION_ELEMENTS<br>DESCRIPTION                                                                                                                                                                | QTY |
| 02-01 | BOG SEAT, MODEL #Q2-BOG-82B. COLOR: NATURAL. FINISH: CRAFTSMAN ETCH W/GRAFFITI-RESISTANT COATING. MANUFACTURED BY QCP (866) 703-3434. INSTALL PER MANUFACTURER'S RECOMMENDATIONS.                          | 6   |
| 02-02 | ROUND TABLE WITH 4 SEATS, MODEL #QR-42FC. COLOR: QUAIL HILL RED. FINISH: CRAFTSMAN ETCH W/GRAFFITI-RESISTANT COATING. MANUFACTURED BY QCP (866) 703-3434. INSTALL PER MANUFACTURER'S RECOMMENDATIONS.      | 1   |
| 02-03 | ROUND TABLE WITH 3 SEATS, MODEL #QR-42FC3-ADA. COLOR: QUAIL HILL RED. FINISH: CRAFTSMAN ETCH W/GRAFFITI-RESISTANT COATING. MANUFACTURED BY QCP (866) 703-3434. INSTALL PER MANUFACTURER'S RECOMMENDATIONS. | 1   |
| 02-04 | WASTE CONTAINER, MODEL #QS-SQ2432WA-F17. COLOR: QUAIL HILL RED. FINISH: CRAFTSMAN ETCH W/GRAFFITI-RESISTANT COATING. MANUFACTURED BY QCP (866) 703-3434. INSTALL PER MANUFACTURER'S RECOMMENDATIONS.       | 3   |
| 02-05 | DRINKING FOUNTAIN, MODEL #10155 SM WITH PET FOUNTAIN AND BOTTLE FILLER. COLOR: TEXTURED BURGANDY. MANUFACTURED BY MOST DEPENDABLE FOUNTAINS (800) 552-6331. INSTALL PER MANUFACTURER'S RECOMMENDATIONS.    | 1   |
| 02-06 | DOG WASTE BAG STATION, MODEL #1002-2. MANUFACTURED BY DOGIPOT (800) 364-7681.                                                                                                                              | 2   |
| 02-07 | INTERPRETIVE SIGNAGE-WETLANDS                                                                                                                                                                              |     |
| 02-08 | INTERPRETIVE SIGNAGE-CITY TO PROVIDE HISTORICAL RAILROAD SIGNAGE GRAPHIC                                                                                                                                   |     |
| 02-09 | PEDESTRIAN LIGHTING. SEE ELECTRICAL PLAN.                                                                                                                                                                  | 9   |
| 02-10 | COMBINATION ELECTRICAL METER/IRRIGATION CONTROLLER ENCLOSURE                                                                                                                                               |     |
| 02-11 | 10' WIDE COLORED CONCRETE MULTI-USE TRAIL                                                                                                                                                                  |     |
| 02-12 | DEMOUNTABLE BOLLARD POST                                                                                                                                                                                   | 4   |
| 02-13 | SUMP FOR DRINKING FOUNTAIN-2'X2'X3'DEEP                                                                                                                                                                    |     |
| 02-14 | CLEANOUT FOR DRINKING FOUNTAIN                                                                                                                                                                             |     |

    PLANT SCHEDULE MUST TREATMENT PLANT

| TREES                                                                                 | CODE   | BOTANICAL NAME / COMMON NAME                                                                                | CONT      | SPACE    | ZONE* | QTY       |
|---------------------------------------------------------------------------------------|--------|-------------------------------------------------------------------------------------------------------------|-----------|----------|-------|-----------|
|    | QU AG  | QUERCUS AGRIFOLIA / COAST LIVE OAK                                                                          | 24"BOX    | AS SHOWN | L/0.3 | 3         |
|     | QU AG2 | QUERCUS AGRIFOLIA / COAST LIVE OAK                                                                          | 36"BOX    | AS SHOWN | L/0.3 | 6         |
|    | QU EN  | QUERCUS ENGLEMANNII / ENGELMANN OAK                                                                         | 24"BOX    | AS SHOWN | L/0.3 | 8         |
| SHRUBS                                                                                | CODE   | BOTANICAL NAME / COMMON NAME                                                                                | CONT      | SPACING  | ZONE* | QTY       |
|    | AR GL  | ARCTOSTAPHYLOS GLAUCA / MANZANITA BIG BERRY                                                                 | 5 GAL     | 6' O.C.  | L/0.2 | 11        |
|    | AR DO  | ARTEMISIA DOUGLASIANA / MUGWORT                                                                             | 1 GAL     | 3' O.C.  | L/0.3 | 6         |
|    | BA PI  | BACCHARIS PILULARIS / DWARF COYOTE BRUSH                                                                    | 1 GAL     | 5' O.C.  | L/0.3 | 46        |
|    | CE CR  | CEANOTHUS CRASSIFOLIUS / HOARYLEAF CEANOTHUS                                                                | 5 GAL     | 7' O.C.  | L/0.2 | 5         |
|    | CE LE  | CEANOTHUS LEUCODERMIS / CHAPARRAL WHITETHORN                                                                | 5 GAL     | 7' O.C.  | L/0.2 | 14        |
|    | CH TE  | CHONDROPETALUM TECTORUM 'EL CAMPO' / CAPE RUSH                                                              | 1 GAL     | 4' O.C.  | L/0.3 | 8         |
|    | DU LA  | DUDLEYA LANCEOLATA / LANCELEAF LIVEFOREVER                                                                  | 1 GAL     | 3' O.C.  | L/0.2 | 24        |
|    | EN CA  | ENCELIA CALIFORNICA / CALIFORNIA ENCELIA                                                                    | 1 GAL     | 4' O.C.  | L/0.2 | 40        |
|    | FR FL  | FREMONTODENDRON CALIFORNICUM / CALIFORNIA FLANNEL BUSH                                                      | 5 GAL     | 8' O.C.  | L/0.2 | 8         |
|    | HE AR  | HETEROMELES ARBUTIFOLIA / TOYON                                                                             | 5 GAL     | 8' O.C.  | L/0.3 | 11        |
|    | JU PA  | JUNCUS PATENS / CALIFORNIA GRAY RUSH                                                                        | 1 GAL     | 3' O.C.  | L/0.3 | 10        |
|    | LE CO  | LEYMUS CONDENSATUS / GIANT WILD RYE                                                                         | 5 GAL     | 4' O.C.  | L/0.3 | 38        |
|    | MU RI  | MUHLENBERGIA RIGENS / DEER GRASS                                                                            | 5 GAL     | 5' O.C.  | L/0.3 | 7         |
|    | OP LI  | OPUNTIA LITTORALIS / SHORE CACTUS                                                                           | 5 GAL     | 7' O.C.  | L/0.2 | 8         |
|    | PE CE  | PENSTEMON CENTRANTHIFOLIUS / SCARLET BUGLER                                                                 | 1 GAL     | 3' O.C.  | L/0.2 | 42        |
|    | RH TR  | RHUS TRILOBATA / SKUNKBUSH SUMAC                                                                            | 5 GAL     | 6' O.C.  | L/0.3 | 17        |
|  | RI AU  | RIBES AUREUM GRACILLIMUM / GOLDEN CURRANT                                                                   | 5 GAL     | 5' O.C.  | L/0.3 | 10        |
|  | RI MA  | RIBES MALVACEUM / CHAPARRAL CURRANT                                                                         | 5 GAL     | 6' O.C.  | L/0.3 | 19        |
|  | RI SP  | RIBES SPECIOSUM / FUCHSIA FLOWERING GOOSEBERRY                                                              | 5 GAL     | 5' O.C.  | L/0.3 | 15        |
|  | RO CA  | ROSA CALIFORNICA / CALIFORNIA WILD ROSE                                                                     | 5 GAL     | 5' O.C.  | L/0.2 | 7         |
|  | SA PU  | SALVIA LEUCOPHYLLA / PURPLE LEAF SAGE                                                                       | 5 GAL     | 5' O.C.  | L/0.2 | 39        |
|  | ST PU  | STIPA PULCHRA / PURPLE NEEDLE GRASS                                                                         | 1 GAL     | 3' O.C.  | L/0.2 | 70        |
| GROUND COVERS                                                                         | CODE   | BOTANICAL NAME / COMMON NAME                                                                                | CONT      | SPACE    | ZONE* | QTY       |
|  | DG     | DISINTEGRATED GRANITE / DESERT GOLD                                                                         | DG        | NA       | NA    | 13,054 SF |
|  | MU     | MULCH / AVAILABLE THROUGH AGUINAGA FERTILIZER ALL AREAS TO RECEIVE 3" THICK                                 | MULCH     | NA       | NA    | 1,612 SF  |
| REVEGETATION MIX                                                                      | CODE   | BOTANICAL NAME / COMMON NAME                                                                                | CONT      | SPACE    | ZONE* | QTY       |
|  | M3     | HYDROSEED MIX AREA 3 (TEMP. PERMANENT OR NON-IRRIGATED) AREAS WITH A GRADE OF 20% OR A TEMPORARY CONDITION. | HYDROSEED | NA       |       | 6,459 SF  |

FN:01664L-1013LC  
DATE: 12/21/18  
PLOT SCALE: 1=1

PRELIMINARY DESIGN PHASE - DATE SUBMITTED

NOT FOR CONSTRUCTION

This document is an interim document and not suitable for construction. As an interim document, it may contain data that is potentially inaccurate or incomplete and is not to be relied upon without the express written consent of the preparer.



Long Beach Municipal Urban Stormwater Treatment


LANDSCAPE CONCEPT - ELEMENTS SCHEDULE

FIELD BOOK  
X.X.X.

PAGE  
X.X.X.

GRAPHIC SCALE  
0 1 2 3

|                     |
|---------------------|
| JOB NO. PWXXXX XX   |
| NO. R- XXXX         |
| SHEET<br>3 OF 3     |
| DRAWING NO.<br>LC-2 |

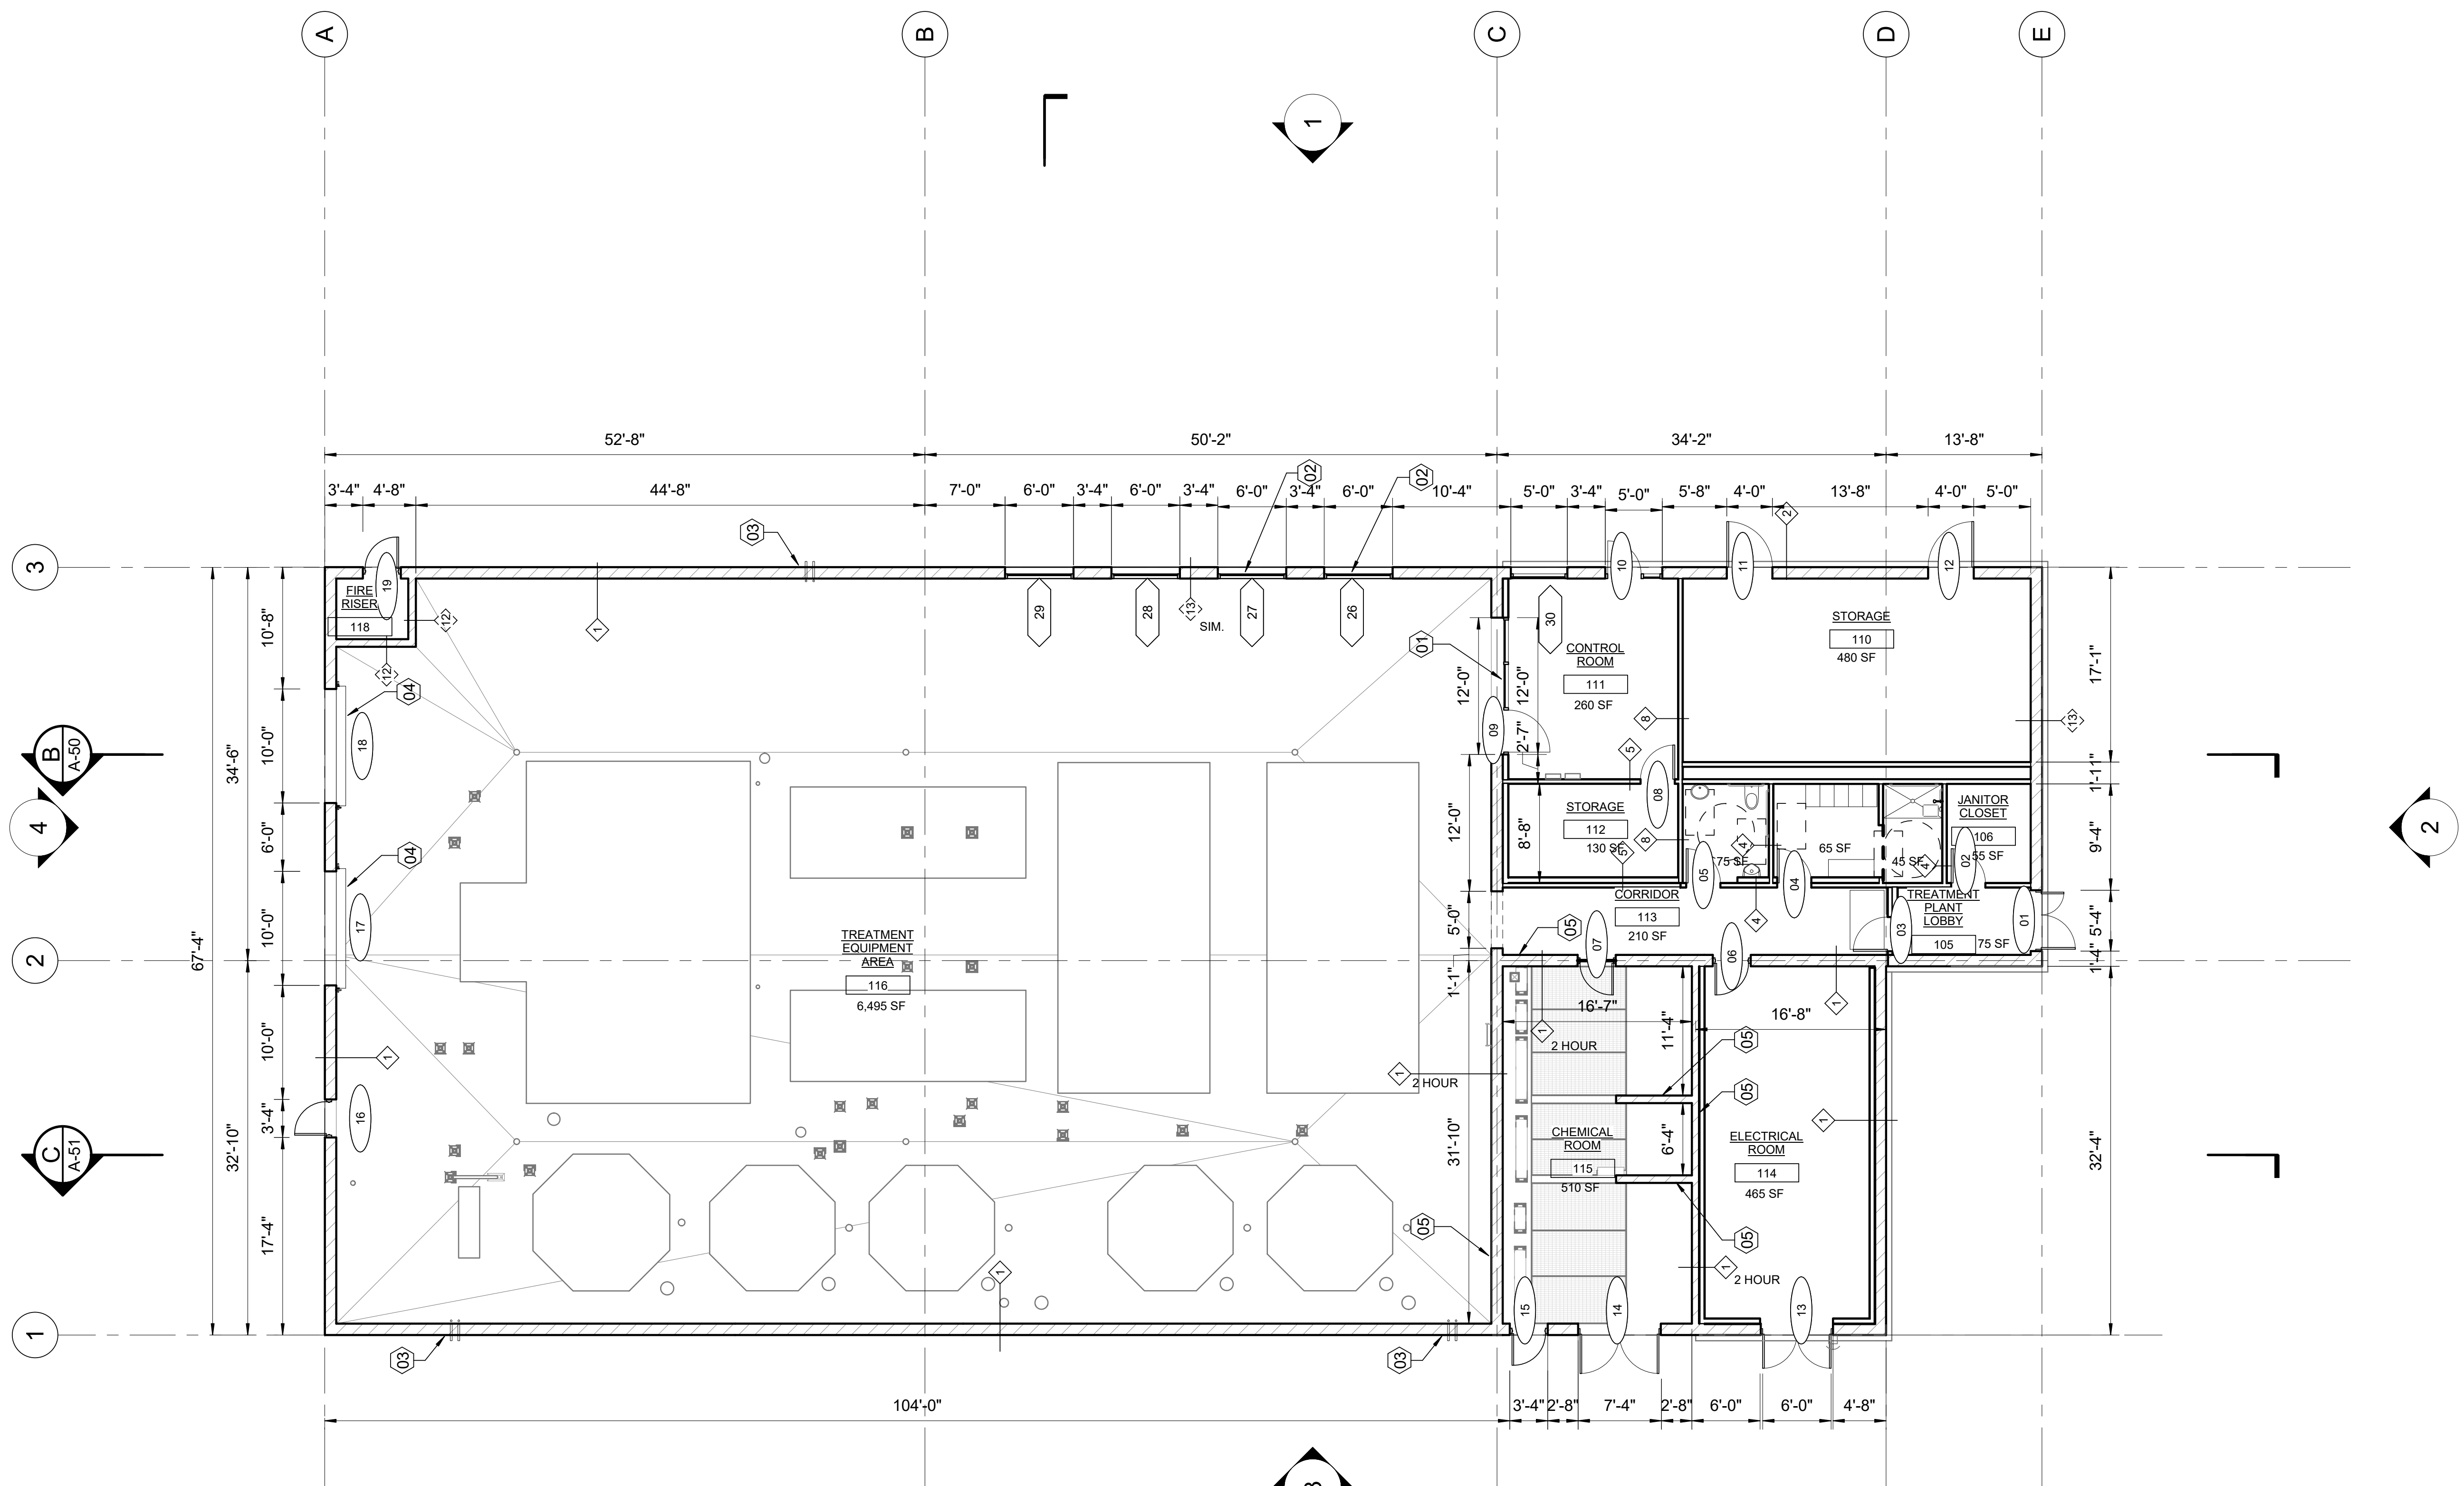


1 FLOOR PLAN  
A-10  
SCALE: 1/8" = 1'-0"


| KEYNOTES                                                                            |                                   | LEGEND                                                                              |                                            |
|-------------------------------------------------------------------------------------|-----------------------------------|-------------------------------------------------------------------------------------|--------------------------------------------|
|  | STOREFRONT WINDOW AND DOOR SYSTEM |  | WALL TYPES<br>SEE SHEET A-60 FOR DETAILS   |
|  | INTERIOR GLASS WALL SYSTEM        |  | WINDOW TYPES<br>SEE SHEET A-70 FOR DETAILS |
|  | DOWNSPOUT AND OVERFLOW            |  | DOOR TYPES<br>SEE SHEET A-70 FOR DETAILS   |
|  | OVERHEAD COILING GRILLE           |  | 1 HR RATED WALLS                           |
|  | SET WALL ON 8" CONCRETE CURB      |  | 2 HR RATED WALLS                           |
|  | 3' DEEP DOOR MAT                  |                                                                                     |                                            |

FN: LB-MUST - ARCH  
DATE: 8/15/18  
PLOT SCALE: 1=1

DESIGN DEVELOPMENT PHASE - SEPTEMBER 2018

**NOT FOR CONSTRUCTION**  
This document is an interim document and not suitable for construction. As an interim document, it may contain data that is potentially inaccurate or incomplete and is not to be relied upon without the express written consent of the preparer.

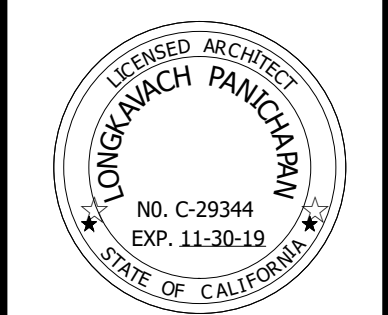

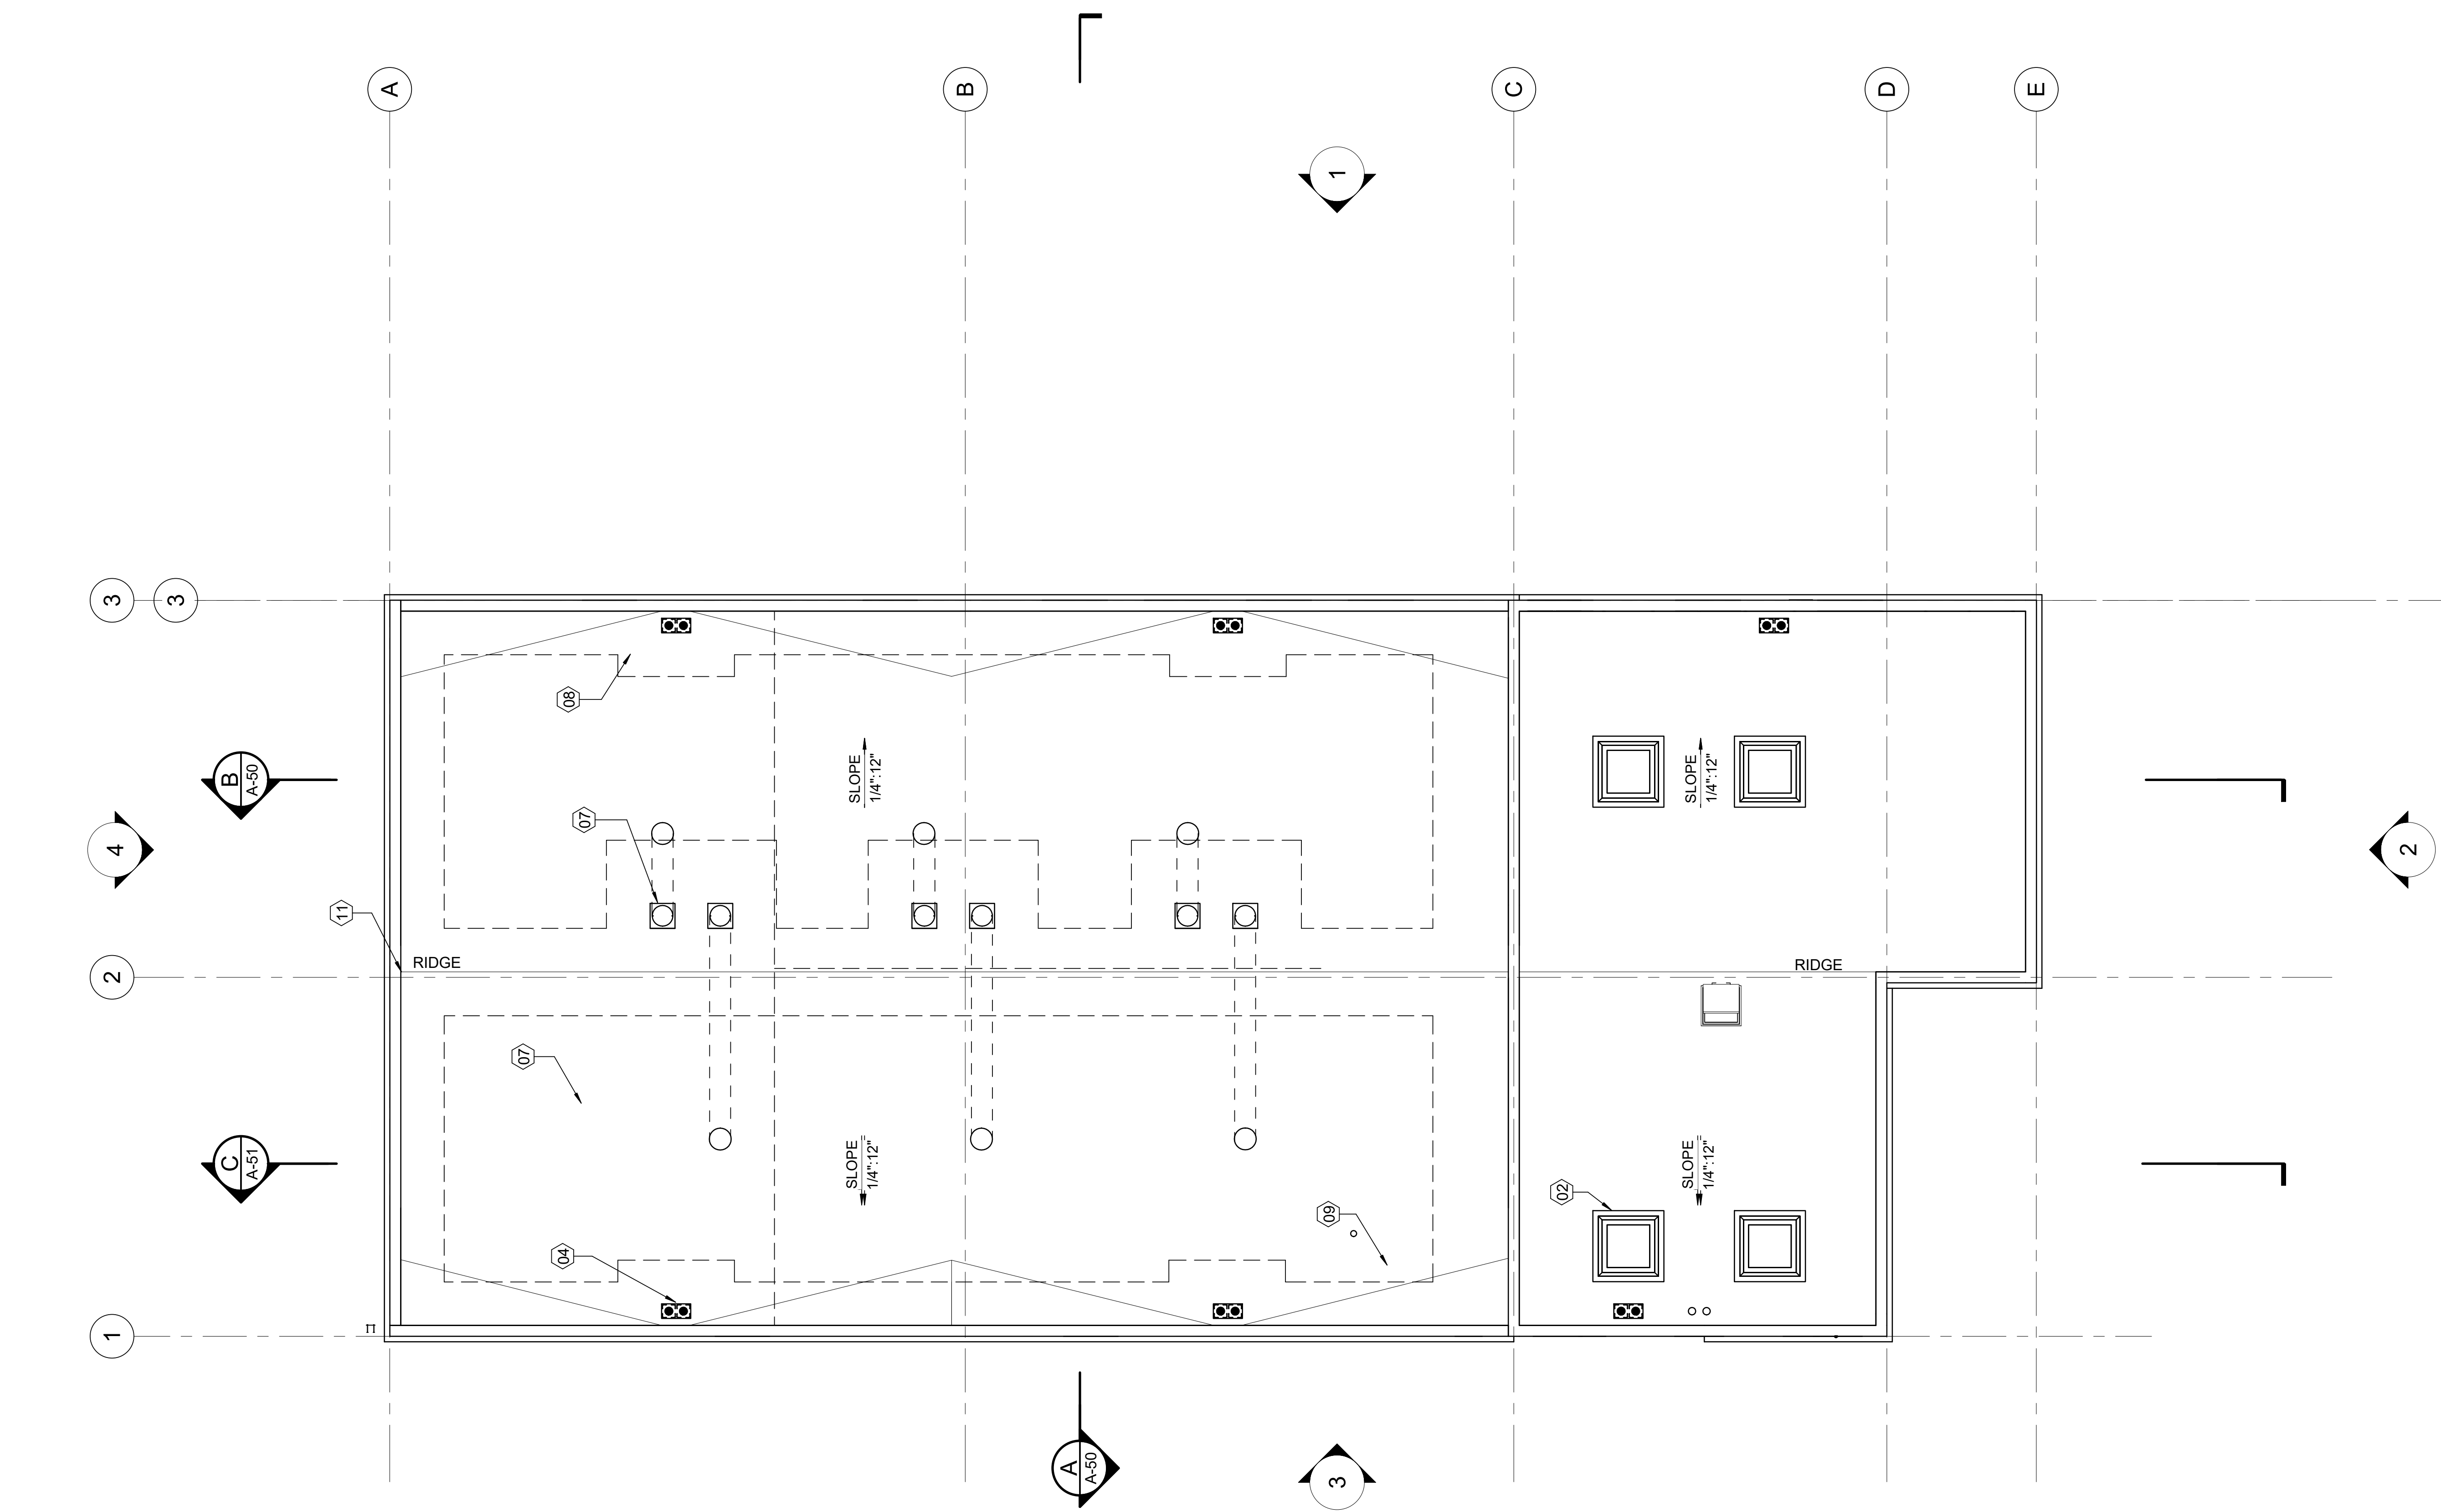

1 ROOF PLAN  
A-20 SCALE: 1/8" = 1'-0"

| SHEET KEYNOTES                       |                                                       |
|--------------------------------------|-------------------------------------------------------|
| 01 SOLATUBE SKYLIGHT                 | 07 SINGLE PLY MEMBRANE ROOFING, SEE SPECS             |
| 02 ROOF MOUNTED MECHANICAL EQUIPMENT | 08 LINE OF FUTURE PHOTO VOLTAIC SOLAR PANEL           |
| 03 METAL SCREEN WALL, SEE SHEET A-XX | 09 ROOF CRICKET                                       |
| 04 ROOF DRAIN AND OVERFLOW           | 10 4" DIA. ROOF DRAIN LINE TO INSIDE OF WALL, SEE ... |
| 05 FASCIA GUTTER SYSTEM              | 11 RIDGE LINE                                         |
| 06 METAL ROOF, SEE SHEET A-XX        | 12 ROOF ACCESS HATCH                                  |

## LEGEND

---


|                                                                                       |                         |
|---------------------------------------------------------------------------------------|-------------------------|
|  | ROOF DRAIN AND OVERFLOW |
|  | TUBE SKYLIGHT           |

DESIGN DEVELOPMENT PHASE - NOVEMBER 2018

**NOT FOR CONSTRUCTION**  
This document is an interim document and not suitable for construction. As an interim document, it may contain data that is potentially inaccurate or incomplete and is not to be relied upon without the express written consent of the preparer.



FN: LB-MUST - ARCH  
DATE: 8/15/18  
PLOT SCALE: 1=1

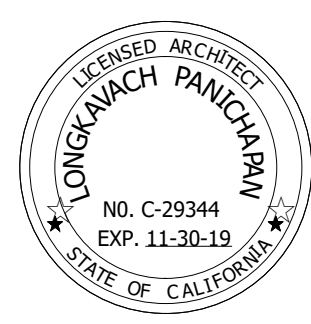

Long Beach Municipal Urban Stormwater Treatment - Treatment Facility

**ROOF PLAN**



# ROOF PLAN

|                      |                |                          |
|----------------------|----------------|--------------------------|
| FIELD BOOK<br>X.X.X. | PAGE<br>X.X.X. | GRAPHIC SCALE<br>0 1 2 3 |
|----------------------|----------------|--------------------------|



| DESIGNED BY:<br>J. Pontichapan |      |       |          |             | REVISIONS |  |      |
|--------------------------------|------|-------|----------|-------------|-----------|--|------|
| No.                            | DATE | SHEET | APPROVAL | DESCRIPTION |           |  |      |
| DRAWN BY:<br>M. Luce           |      |       |          |             |           |  |      |
| DESIGN CHECK BY:<br>X.X.X.     |      |       |          |             |           |  |      |
| DRAFTING CHECK BY:             |      |       |          |             |           |  |      |
| AS BUILT:                      |      |       |          |             |           |  | REF. |

PLOT DATE: 12/21/2018 11:07:48 AM SAVED PATH: B:\40437122\LB MUST-ARCH.rvt Version: 2017

1 EAST ELEVATION  
A-30 SCALE: 1/8" = 1'-0"

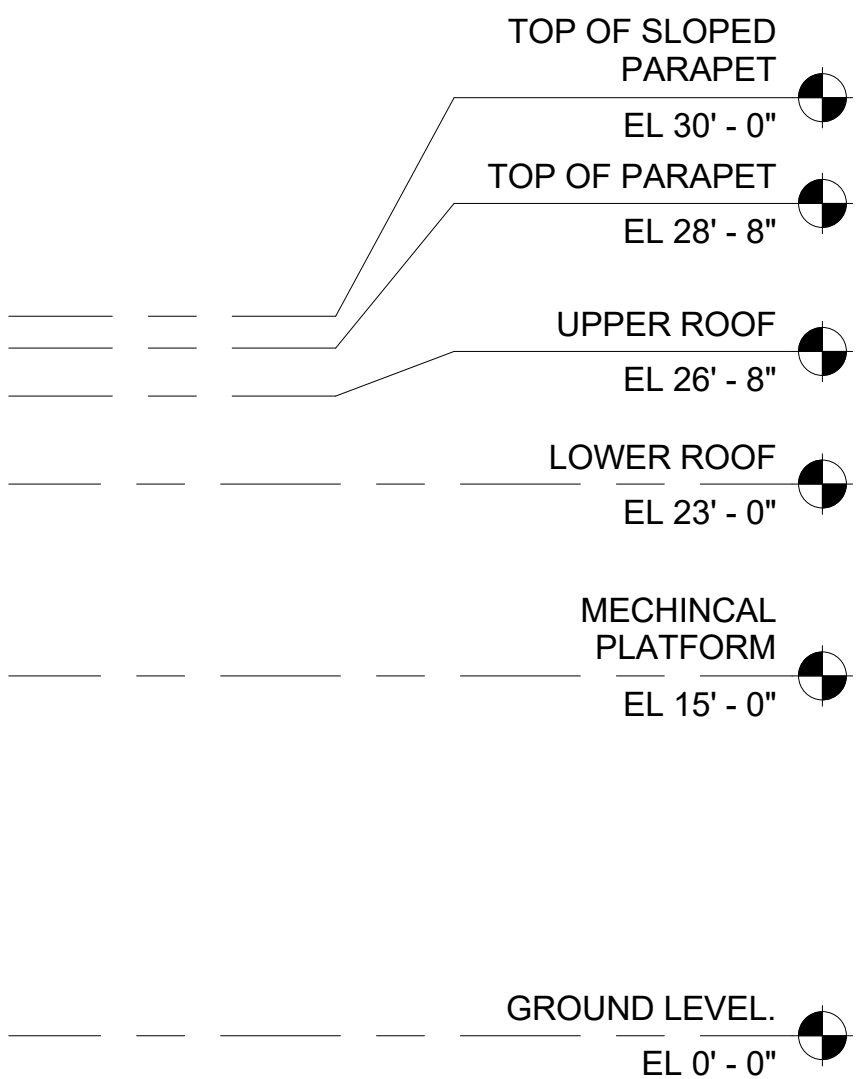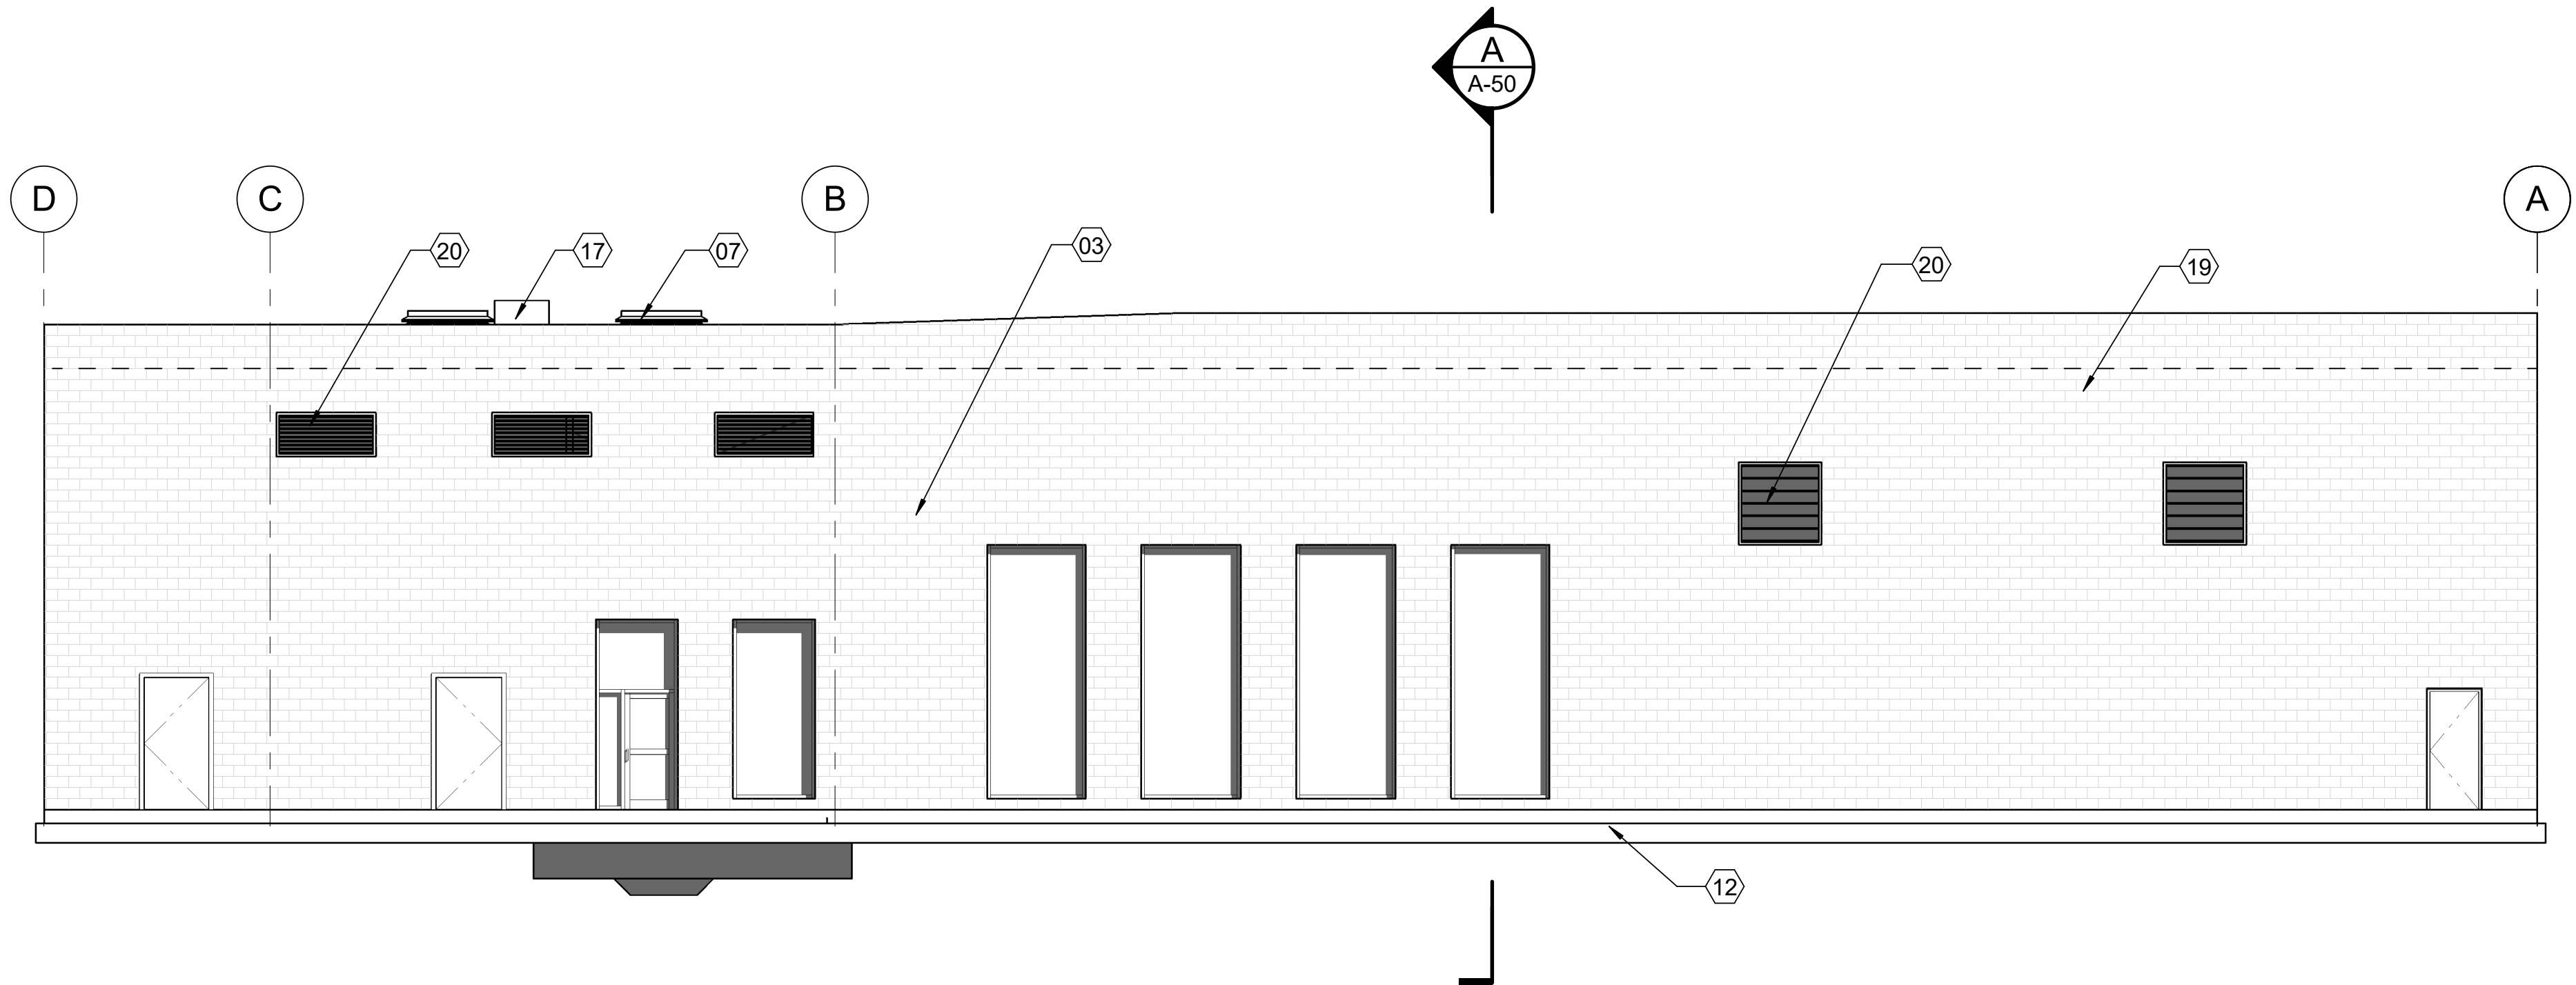

2 SOUTH ELEVATION  
A-30 SCALE: 1/8" = 1'-0"

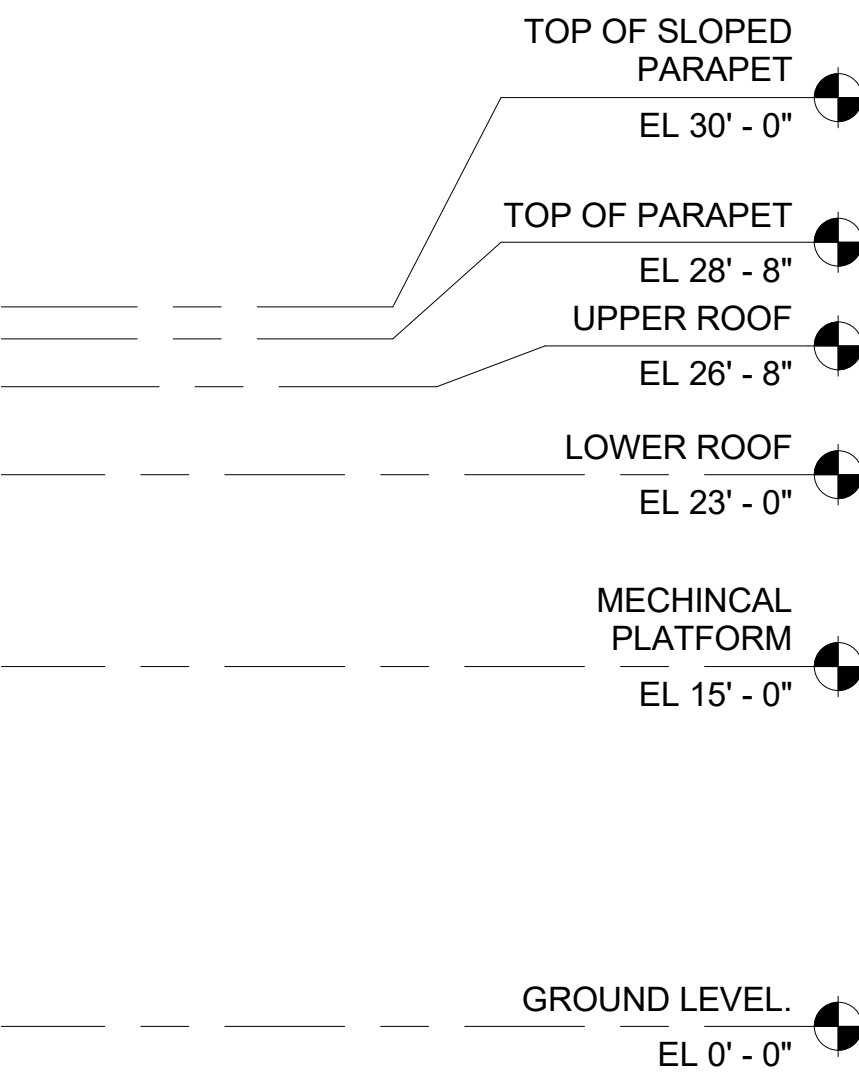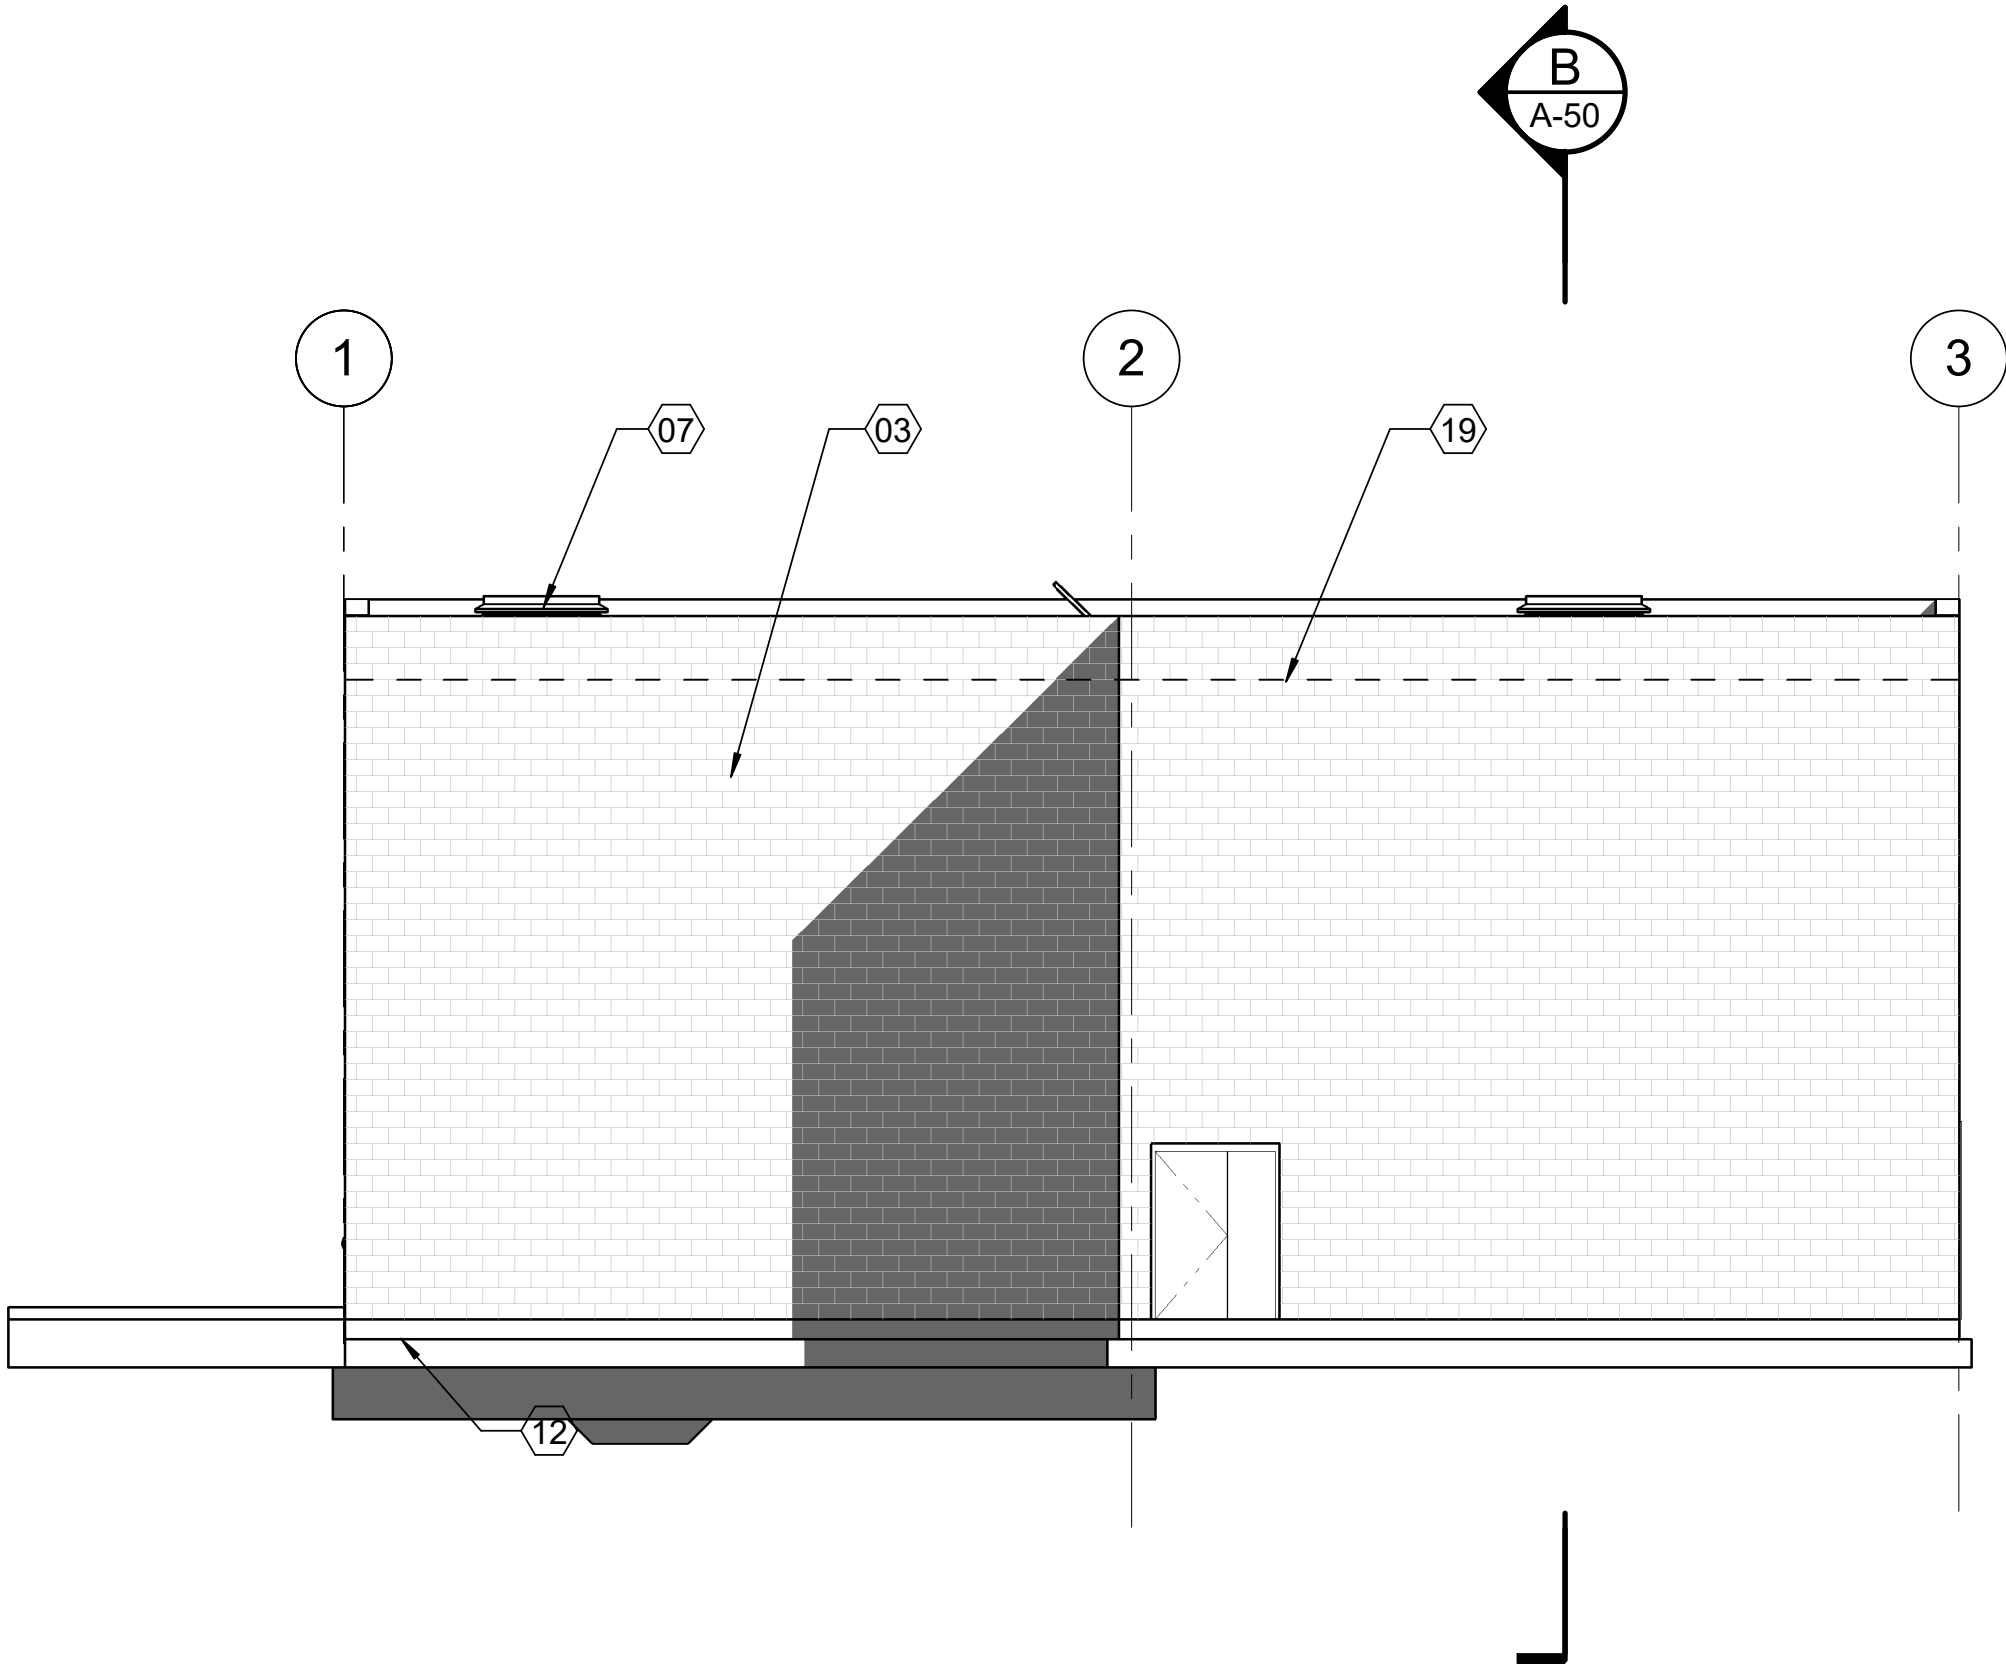

KEYNOTES

- |                             |                                  |                                  |                       |
|-----------------------------|----------------------------------|----------------------------------|-----------------------|
| 01 METAL PANEL SCREEN WALL  | 07 MECHANICAL UNITS BEYOND       | 13 DECORATIVE SUPPORT RAFTERS    | 19 ROOF LINE BEYOND   |
| 02 METAL FLASHING CAP       | 08 EXTERIOR LIGHT FIXTURE, TYP.  | 14 HEAVY TIMBER STRUCTURAL BEAMS | 20 MECHANICAL LOUVERS |
| 03 CMU BLOCK- TYPE I        | 09 CONTROL JOINTS                | 15 TILTED PLASTER WALL           |                       |
| 04 CMU BLOCK- TYPE II       | 10 SCRUPPER AND OVERFLOW, SEE... | 16 GUTTER SYSTEM                 |                       |
| 05 METAL STANDING SEAM ROOF | 11 8" CONCRETE CURB              | 17 ROOF ACCESS HATCH BEYOND      |                       |
| 06 FASCIA GUTTER SYSTEM     | 12 BLDG. SLAB, SLOPE TO DRAIN    | 18 SOLATUBE SKYLIGHTS            |                       |

HATCH LEGEND

- |                    |
|--------------------|
| CMU BLOCK- TYPE I  |
| CMU BLOCK- TYPE II |

DESIGN DEVELOPMENT PHASE - NOVEMBER 2018

NOT FOR CONSTRUCTION  
This document is an interim document and not suitable for construction. As an interim document, it may contain data that is potentially inaccurate or incomplete and is not to be relied upon without the express written consent of the preparer.



architecture • interior • planning

Gillis + Panichapan


Architects, Incorporated



LONG BEACH

Long Beach Municipal Urban Stormwater Treatment - Treatment Facility  
ELEVATIONS- I

|                  |
|------------------|
| JOB NO. PWXXX XX |
| NO. R- XXXX      |
| SHEET XX OF XX   |
| DRAWING NO. A-30 |

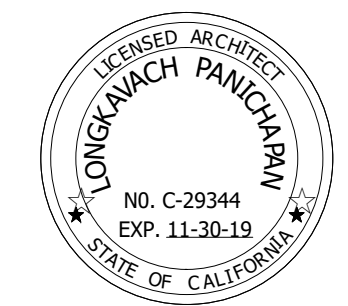

| DESIGNED BY:  |      | DRAWN BY: |  | DESIGN CHECK BY: |  | DRAFTING CHECK BY: |  |
|---------------|------|-----------|--|------------------|--|--------------------|--|
| J. Panichapan |      | M. Luce   |  | X.X.X.           |  | X.X.X.             |  |
| REVISIONS     |      | APPROVAL  |  | SHEET            |  | REF.               |  |
| No.           | DATE |           |  |                  |  |                    |  |
|               |      |           |  |                  |  |                    |  |
|               |      |           |  |                  |  | AS BUILT:          |  |



PAGE X.X.X.

FIELD BOOK X.X.X.

FN: LB-MUST - ARCH  
DATE: 8/15/18  
PLOT SCALE: 1=1




| KEYNOTES |                          |    |                               | HATCH LEGEND |                               |
|----------|--------------------------|----|-------------------------------|--------------|-------------------------------|
| 01       | METAL PANEL SCREEN WALL  | 07 | MECHANICAL UNITS BEYOND       | 13           | DECORATIVE SUPPORT RAFTERS    |
| 02       | METAL FLASHING CAP       | 08 | EXTERIOR LIGHT FIXTURE, TYP.  | 14           | HEAVY TIMBER STRUCTURAL BEAMS |
| 03       | CMU BLOCK- TYPE I        | 09 | CONTROL JOINTS                | 15           | TILTED PLASTER WALL           |
| 04       | CMU BLOCK- TYPE II       | 10 | SCRUPPER AND OVERFLOW, SEE... | 16           | GUTTER SYSTEM                 |
| 05       | METAL STANDING SEAM ROOF | 11 | 8" CONCRETE CURB              | 17           | ROOF ACCESS HATCH BEYOND      |
| 06       | FASCIA GUTTER SYSTEM     | 12 | BLDG. SLAB, SLOPE TO DRAIN    | 18           | SOLATUBE SKYLIGHTS            |
|          |                          |    |                               | 19           | ROOF LINE BEYOND              |
|          |                          |    |                               | 20           | MECHANICAL LOUVERS            |
|          |                          |    |                               |              | CMU BLOCK- TYPE I             |
|          |                          |    |                               |              | CMU BLOCK- TYPE II            |

DESIGN DEVELOPMENT PHASE - NOVEMBER 2018

**NOT FOR CONSTRUCTION**  
This document is an interim document and not suitable for construction. As an interim document, it may contain data that is potentially inaccurate or incomplete and is not to be relied upon without the express written consent of the preparer.

 
FN: LB-MUST - ARCH  
DATE: 8/15/18  
PLOT SCALE: 1=1



|                                                                                      |                   |  |                      |  |                |                  |                                                                        |      |       |          |             |
|--------------------------------------------------------------------------------------|-------------------|--|----------------------|--|----------------|------------------|------------------------------------------------------------------------|------|-------|----------|-------------|
| LONG BEACH                                                                           | JOB NO. PWWXXX XX |  | FIELD BOOK<br>X.X.X. |  | PAGE<br>X.X.X. | GRAPHIC<br>SCALE | <div><div></div><div>0</div><div>1</div><div>2</div><div>3</div></div> |      |       |          |             |
|                                                                                      | NO. R - XXXX      |  |                      |  |                |                  |                                                                        |      |       |          |             |
|                                                                                      | SHEET             |  |                      |  |                |                  |                                                                        |      |       |          |             |
|                                                                                      | _____ OF XX       |  |                      |  |                |                  |                                                                        |      |       |          |             |
|                                                                                      | DRAWING NO.       |  |                      |  |                |                  |                                                                        |      |       |          |             |
|                                                                                      | Δ - 31            |  |                      |  |                |                  |                                                                        |      |       |          |             |
|                                                                                      |                   |  |                      |  |                |                  |                                                                        |      |       |          |             |
| Long Beach Municipal Urban Stormwater Treatment - Treatment Facility                 |                   |  |                      |  |                |                  |                                                                        |      |       |          |             |
| ELEVATIONS- II                                                                       |                   |  |                      |  |                |                  |                                                                        |      |       |          |             |
|  |                   |  |                      |  |                |                  |                                                                        |      |       |          |             |
| DESIGNED BY:<br>J. Panichapan                                                        |                   |  |                      |  |                |                  | REVISIONS                                                              |      |       |          |             |
| DRAWN BY:<br>M. Luce                                                                 |                   |  |                      |  |                |                  | No.                                                                    | DATE | SHEET | APPROVAL | DESCRIPTION |
| DESIGN CHECK BY:<br>X.X.X.                                                           |                   |  |                      |  |                |                  |                                                                        |      |       |          |             |
| DRAFTING CHECK BY:                                                                   |                   |  |                      |  |                |                  | AS BUILT:                                                              |      | REF.  |          |             |

**LB MUST**  
Conceptual Package- Treatment Plant  
November 29, 2018



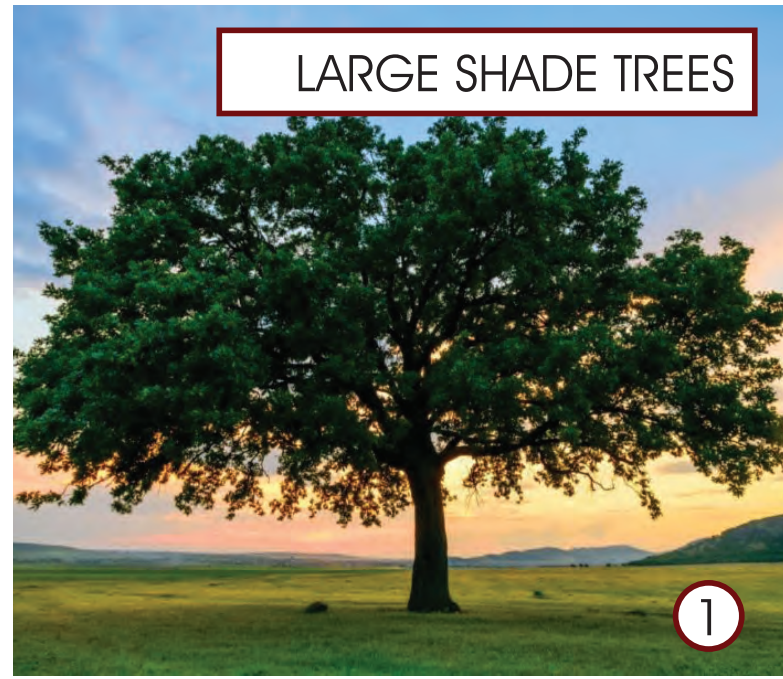

LARGE SHADE TREES

1

LARGE SHADE TREES- LOWERS URBAN HEAT



RAIN GARDEN/BIOSWALE

2

RAIN GARDEN- PART OF THE STORM DRAINAGE PRE-TREATMENT TRAIN



PLANTING SIGNAGE

3

SMALL PLANT LABELS AT THE BASE OF SOME PLANTS IDENTIFYING THE SCIENTIFIC AND COMMON NAMES



KIOSK DIRECTORY

4

KIOSK DIRECTORY- (1 KIOSK TYPE SIGN INCULDING CARTOON OF THE SITE SHOWING VARIOUS LID ELEMENTS



PERMEABLE PAVEMENT

5

PAVEMENT ENHAMCEMENT- PERVIOUS DISINTEGRATED GRANITE PAVEMENT (LESS POLLUTANT RUNOFF INTO STORM DRAINS AND OCEAN)



POW WOW MURAL

6

POW WOW MURAL- INTEGRATION OF LONG BEACH POW WOW MURAL ON NORTH/WEST/EAST PORTION OF BUILDING



\* MURAL IS ARTISTIC CONCEPTION. FOR ILLUSTRATIVE PURPOSES ONLY.




NATIVE PLANTS



7

LOW WATER USE NATIVE PLANTS- SAVES WATER; LESS CHEMICALS FOR HEALTHY PLANTS; CONTRIBUTES LESS TO THE LANDFILLS

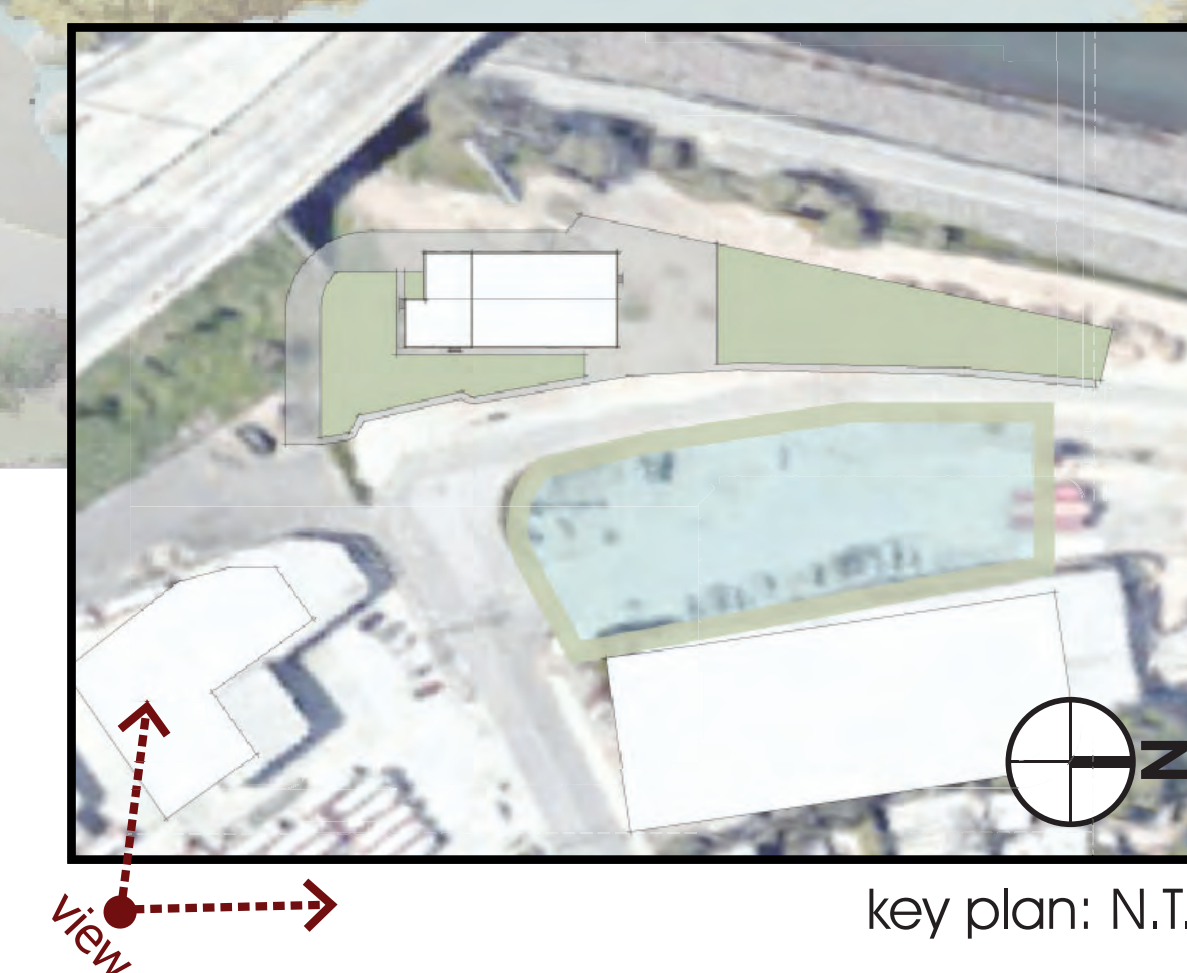
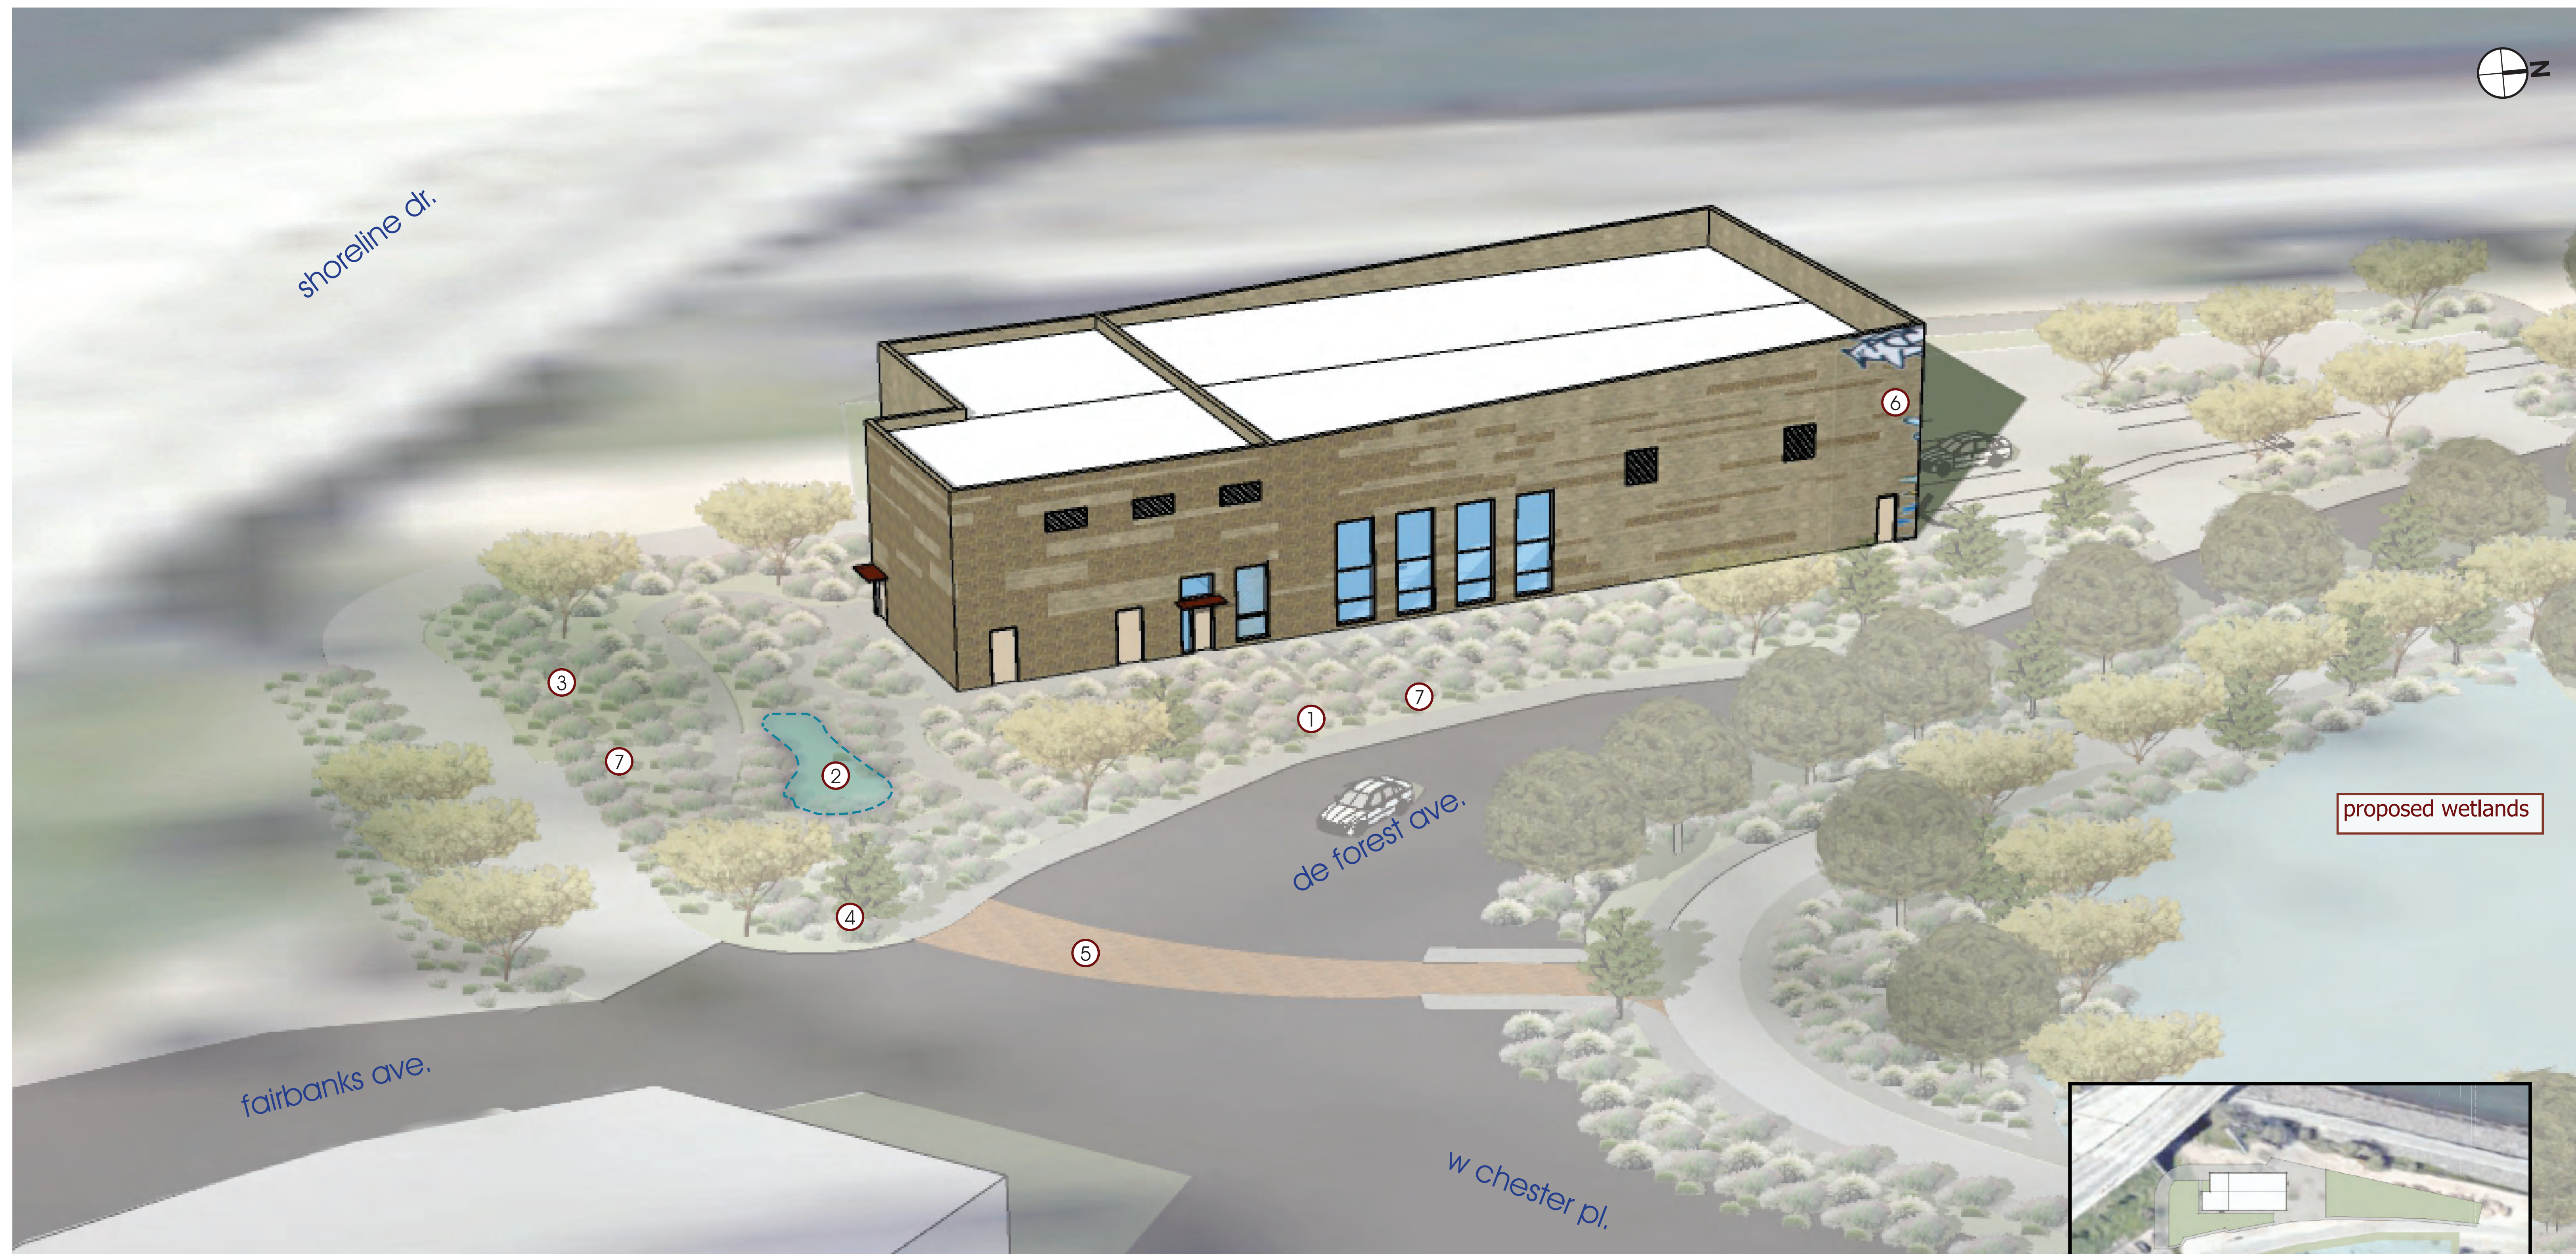


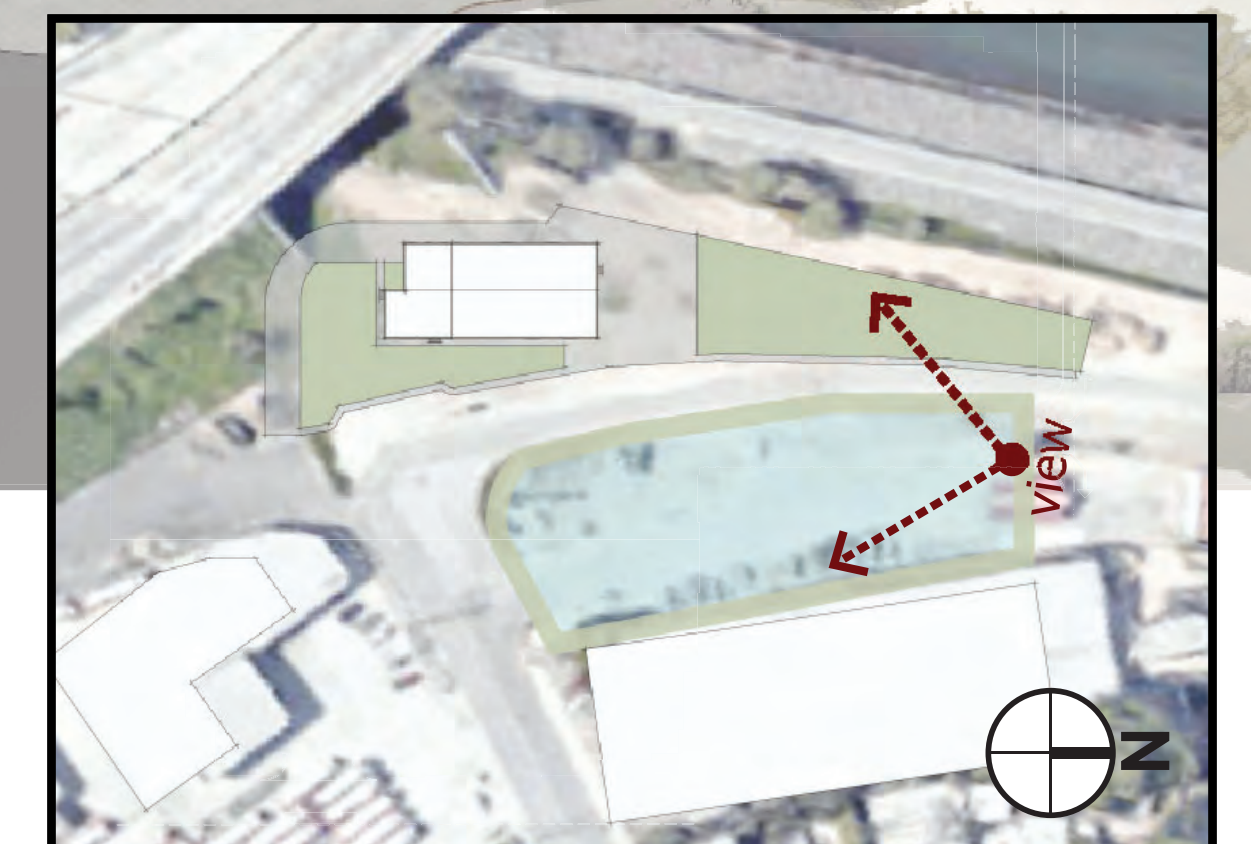


key plan: N.T.S.

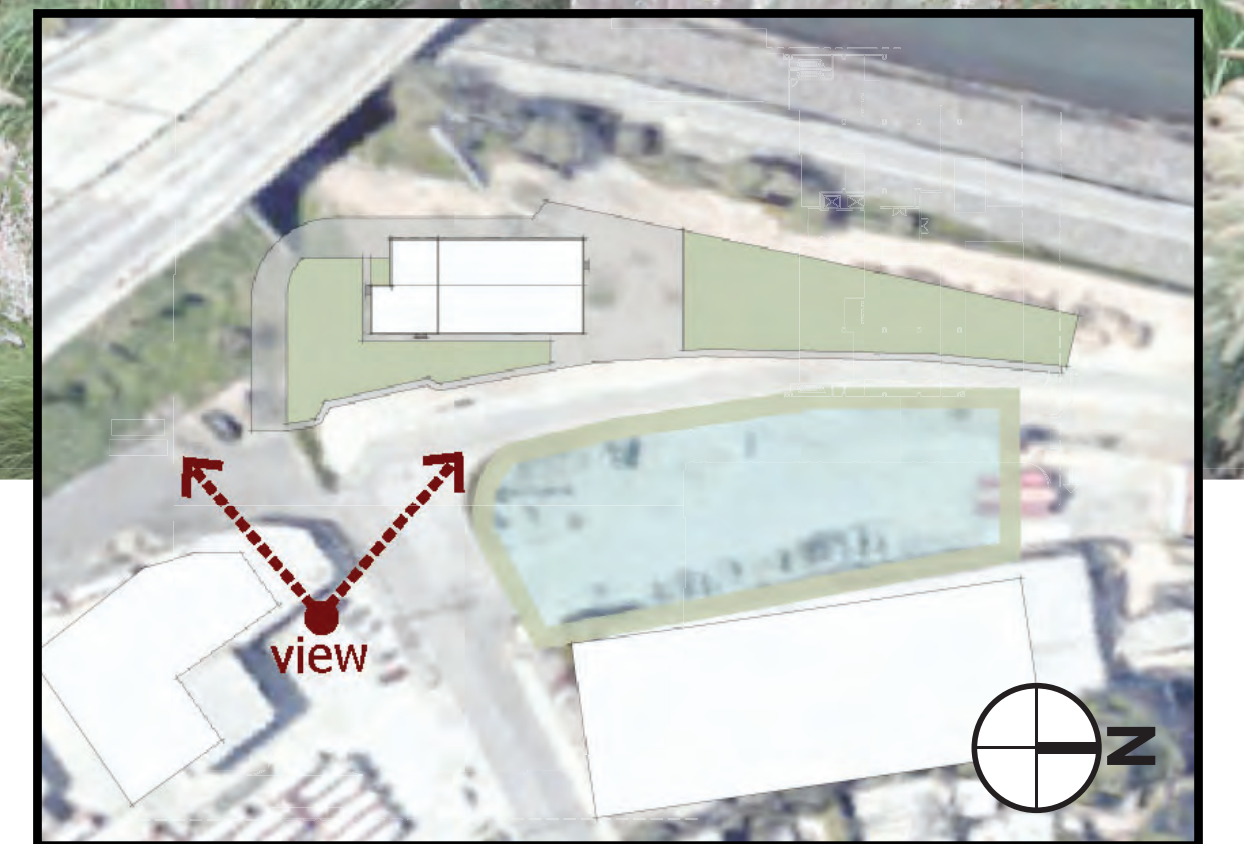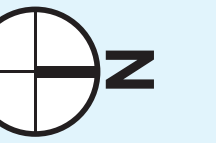

key plan: N.T.S.

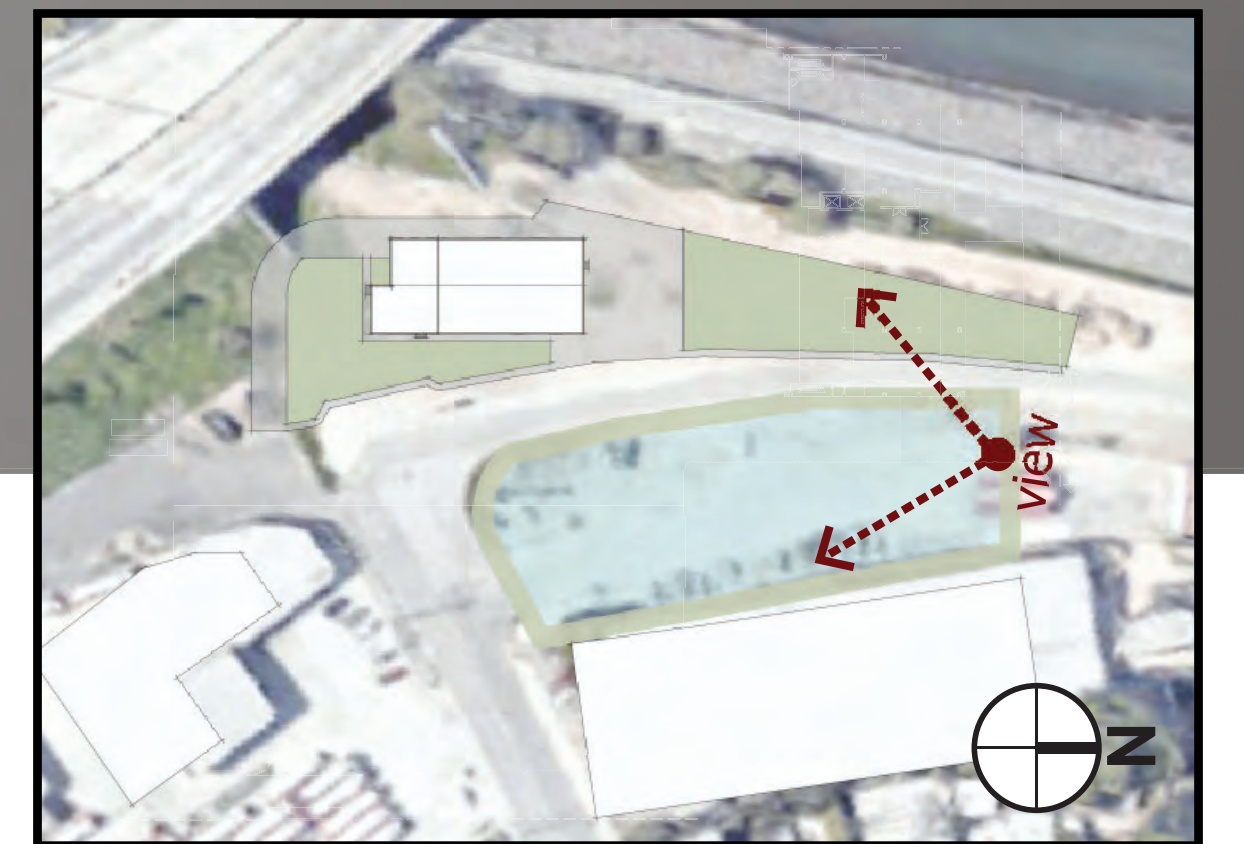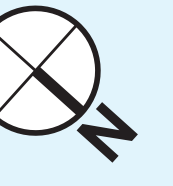


key plan: N.T.S.

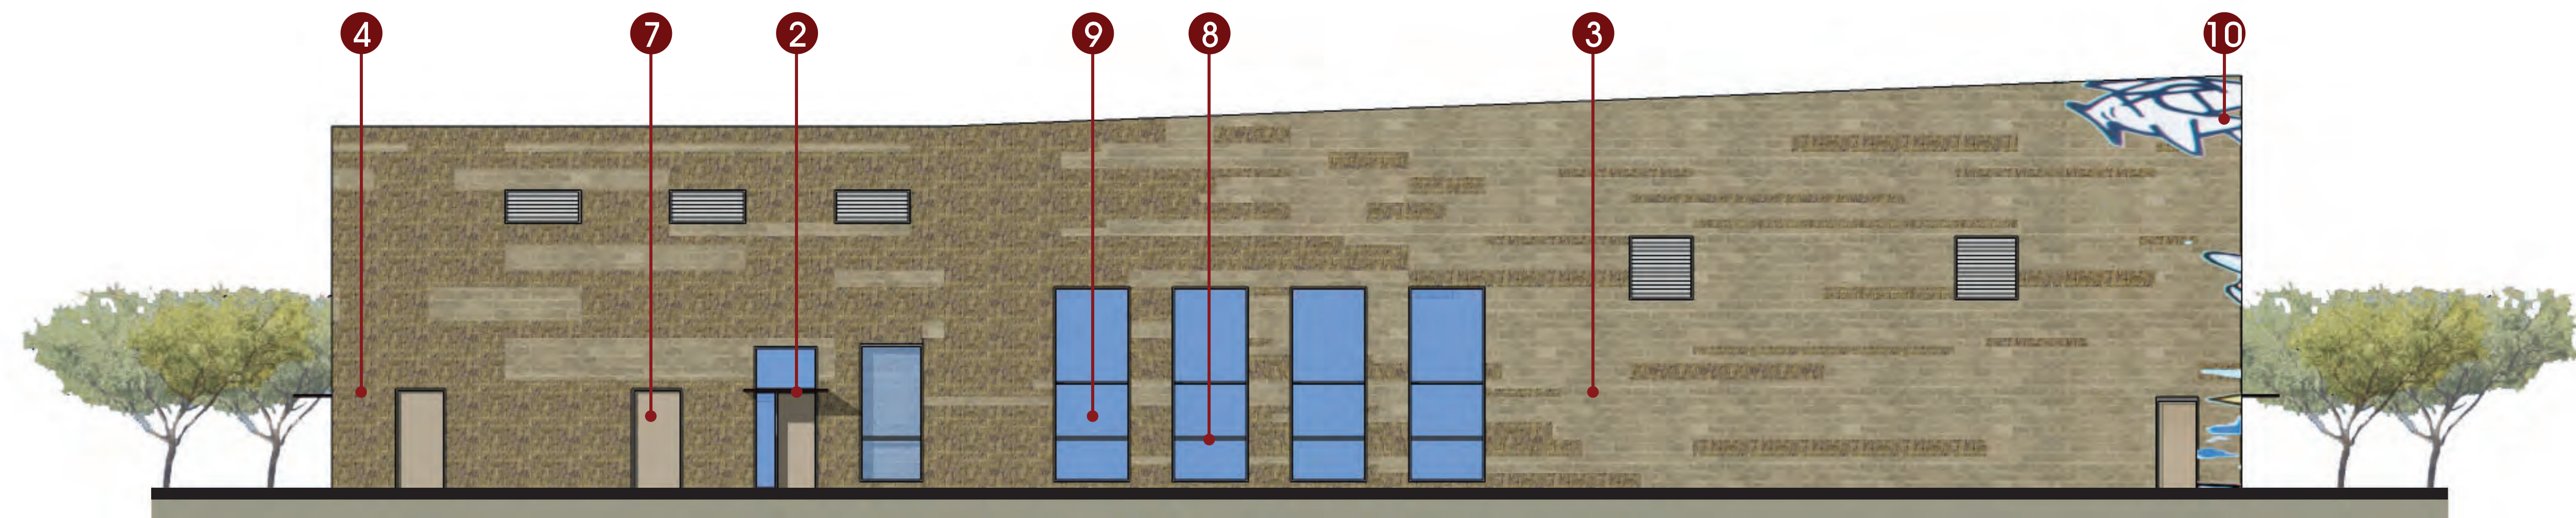


**east elevation**  
scale: 1/16" = 1'-0"


| MATERIALS LEGEND |                                                             |
|------------------|-------------------------------------------------------------|
| 1                | material #1 (not used)                                      |
| 2                | material #2- metal canopy                                   |
| 3                | material #3- cmu block 1                                    |
| 4                | material #4- cmu block 2                                    |
| 5                | material #5 (not used)                                      |
| 6                | material #6 (not used)                                      |
| 7                | material #7- paint                                          |
| 8                | material #8- mullion                                        |
| 9                | material #9- glazing                                        |
| 10               | mural (artistic conception, for illustrative purposes only) |

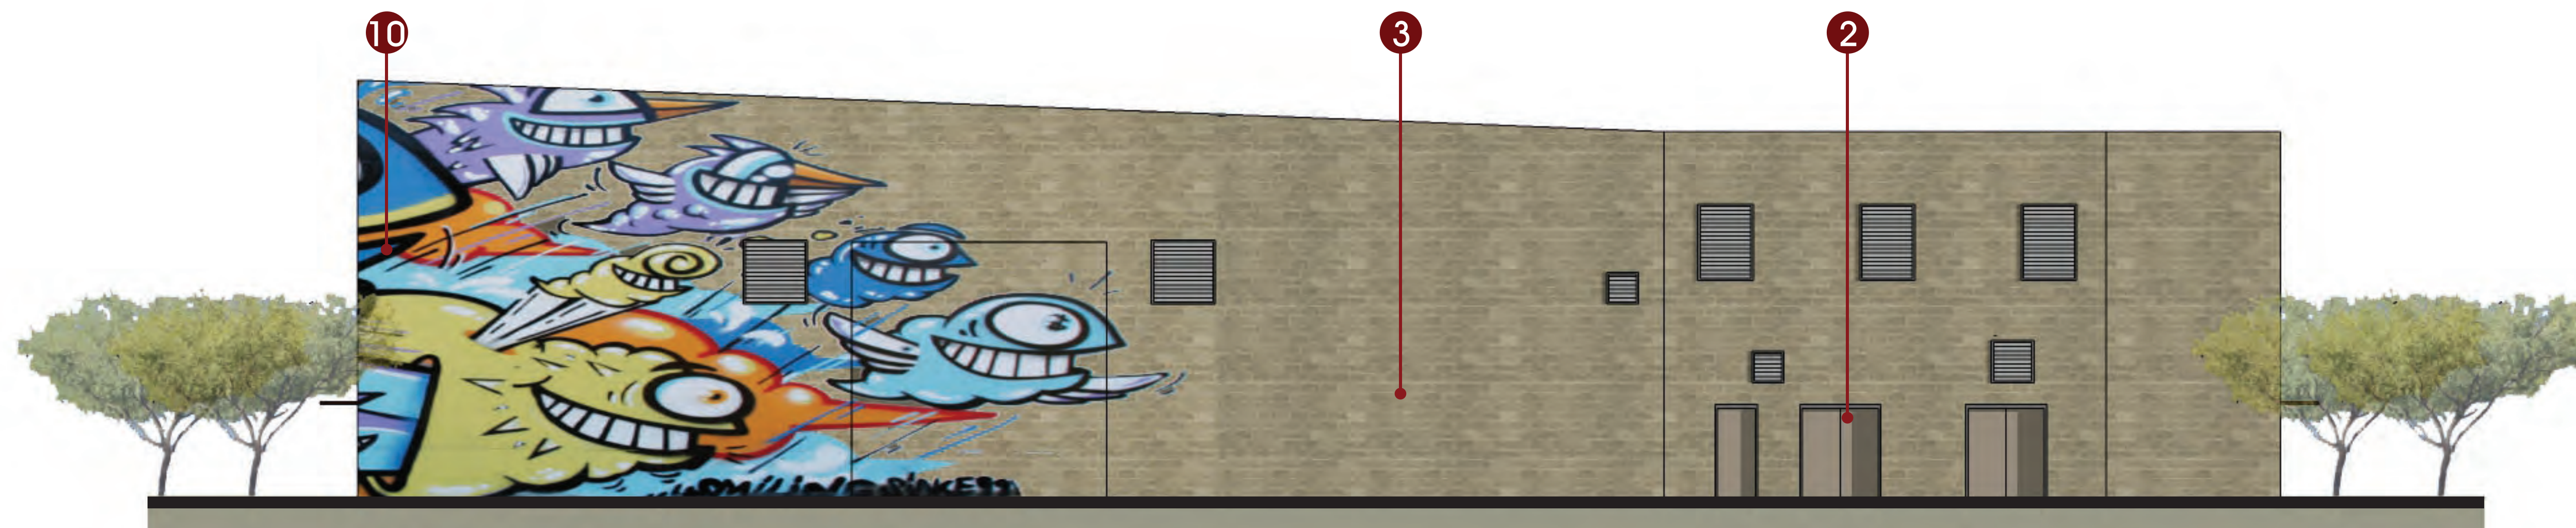

**west elevation**  
scale: 1/16" = 1'-0"

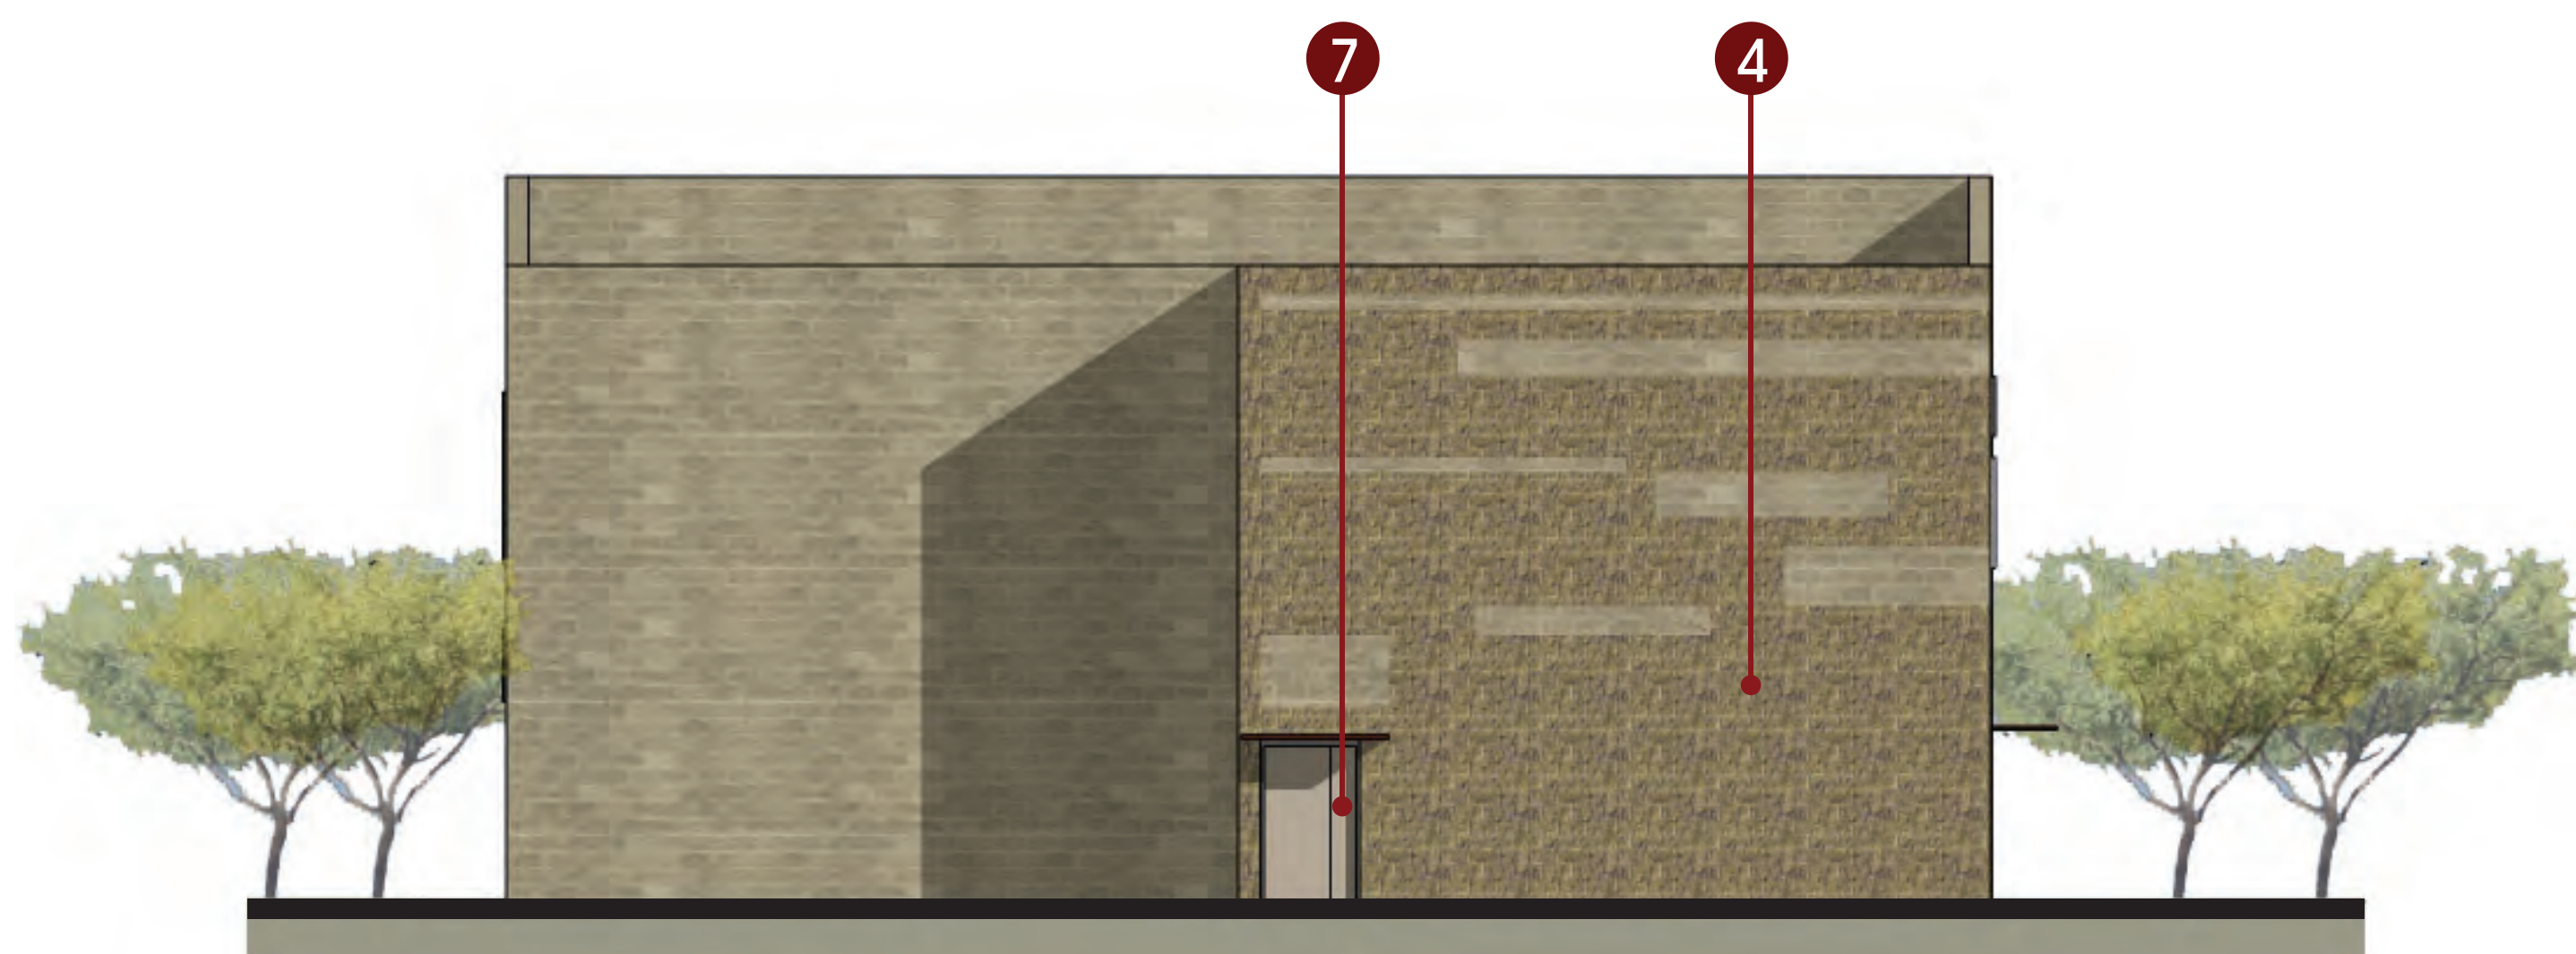



**south elevation**  
scale: 1/16" = 1'-0"

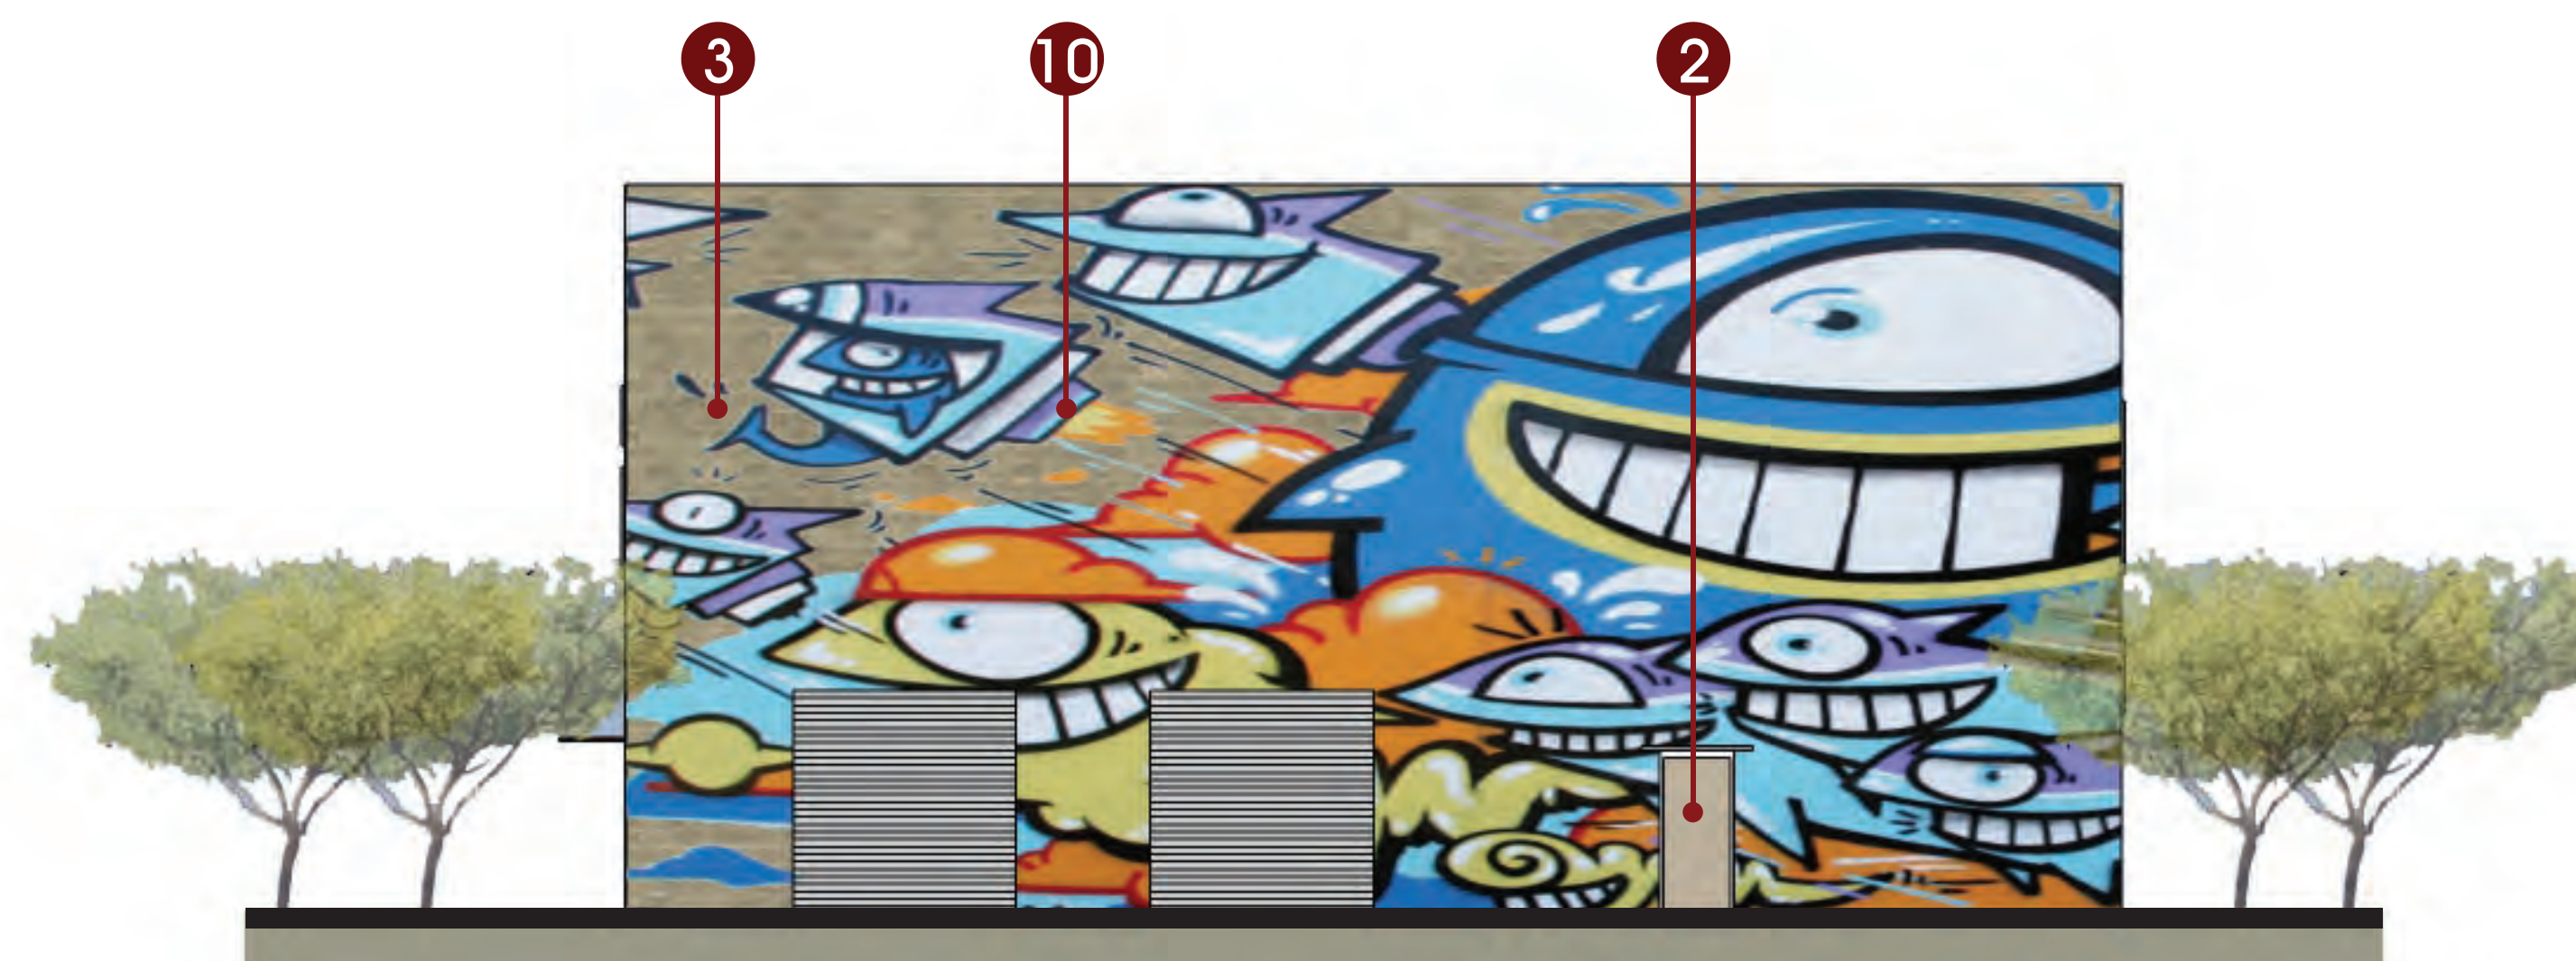

**north elevation**  
scale: 1/16" = 1'-0"

\*note- the mural on plans is for illustrative purposes only.




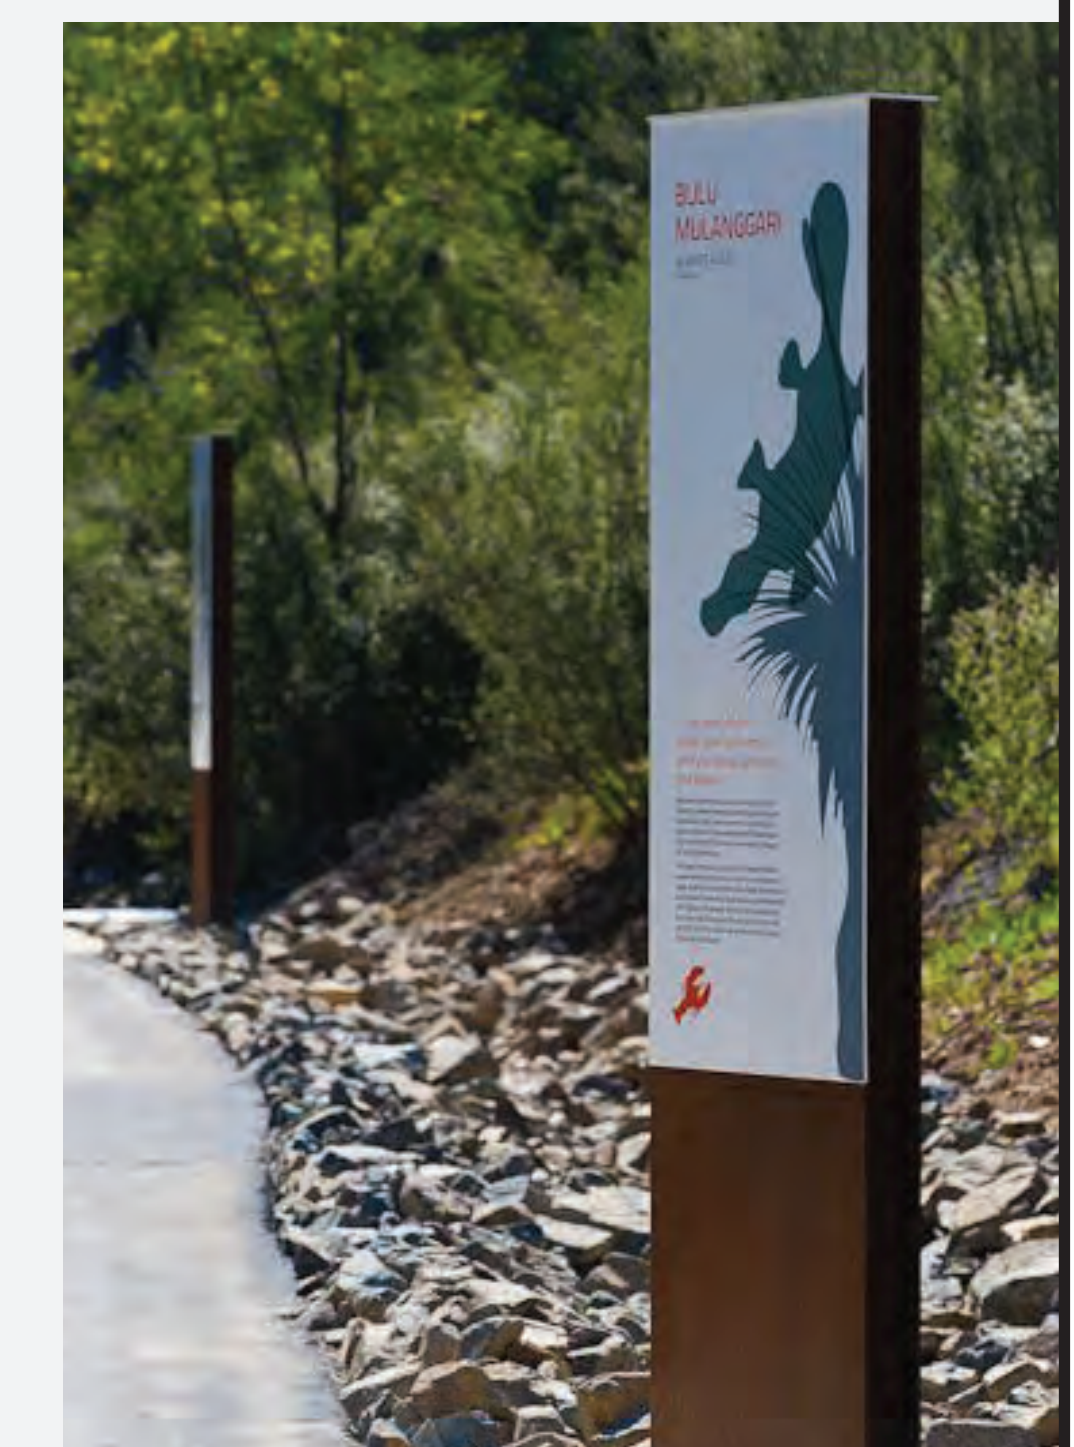
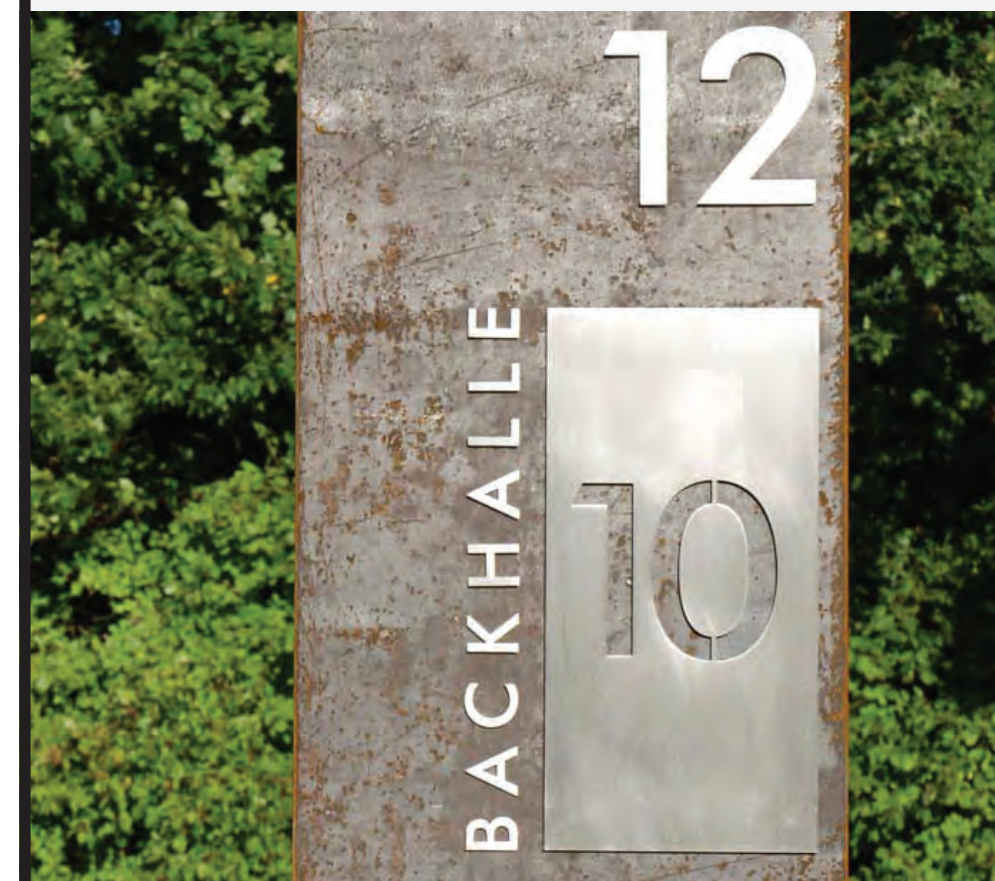


Permeable Pavers




Bioswales



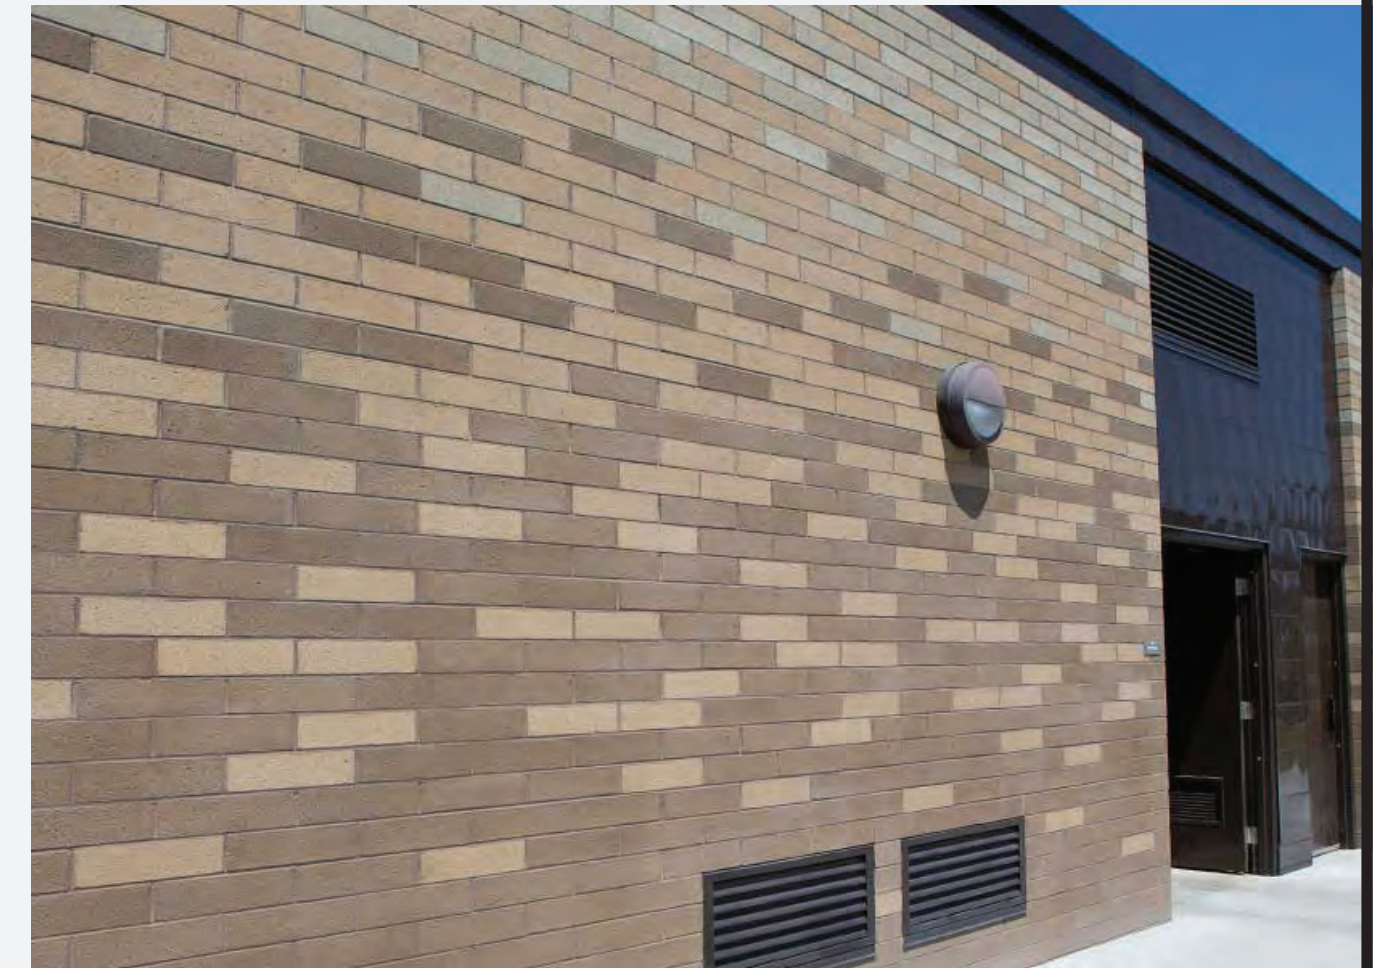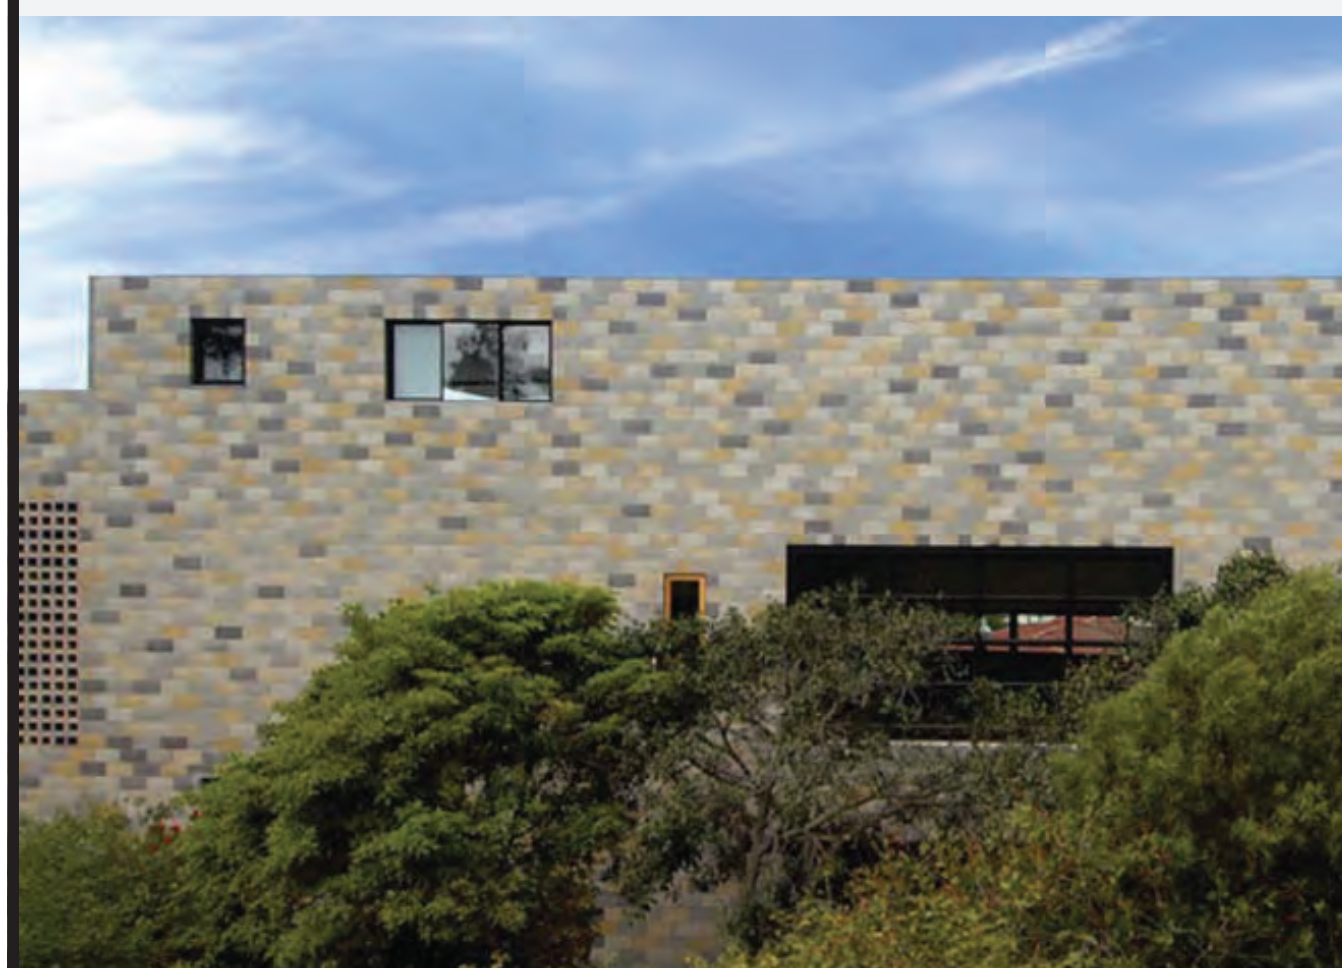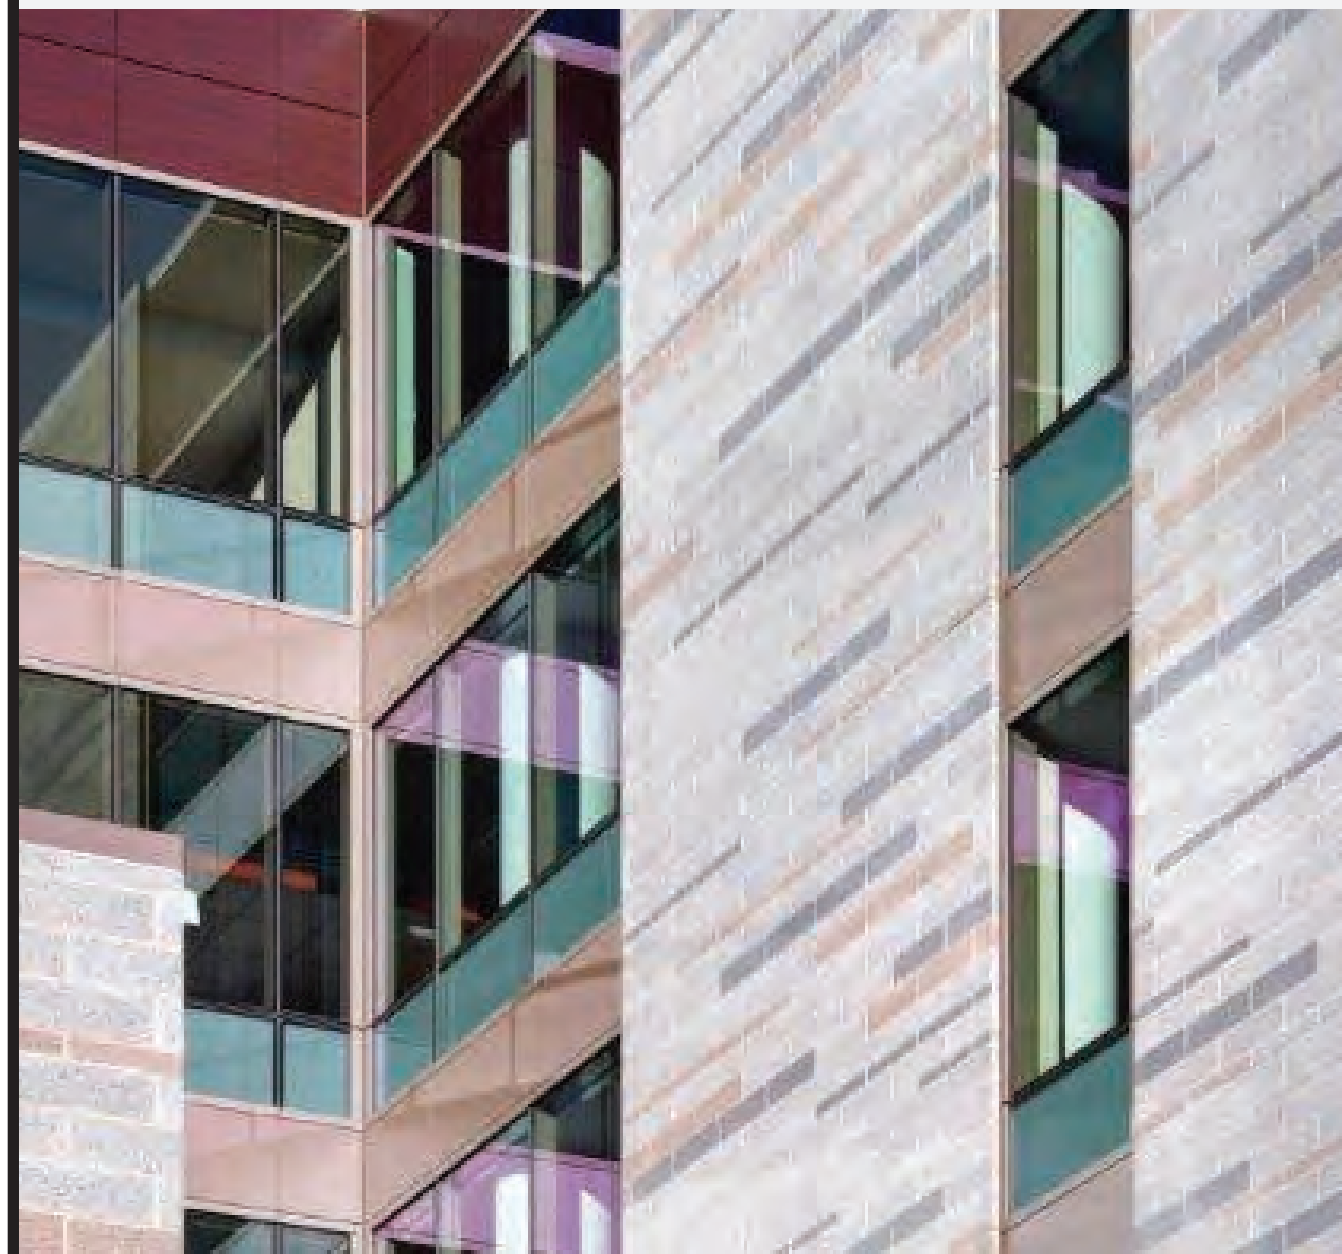



MATERIAL #1

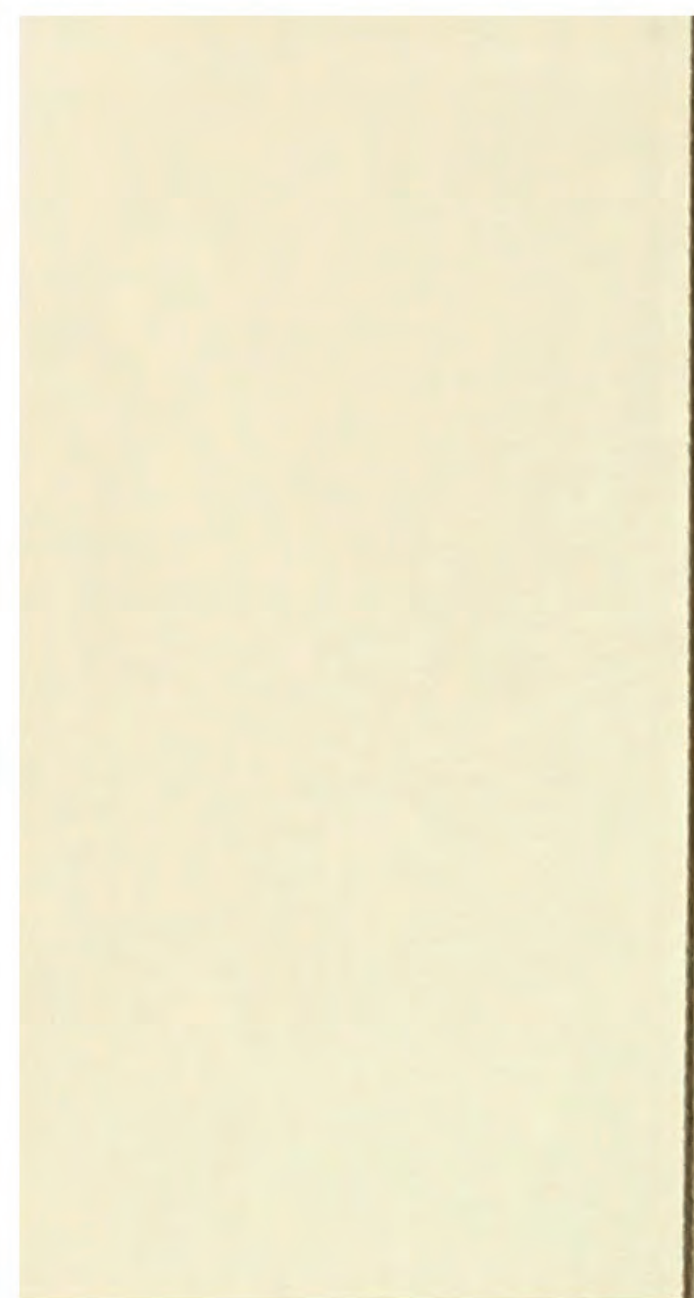


MATERIAL #2





MATERIAL #3




MATERIAL #4

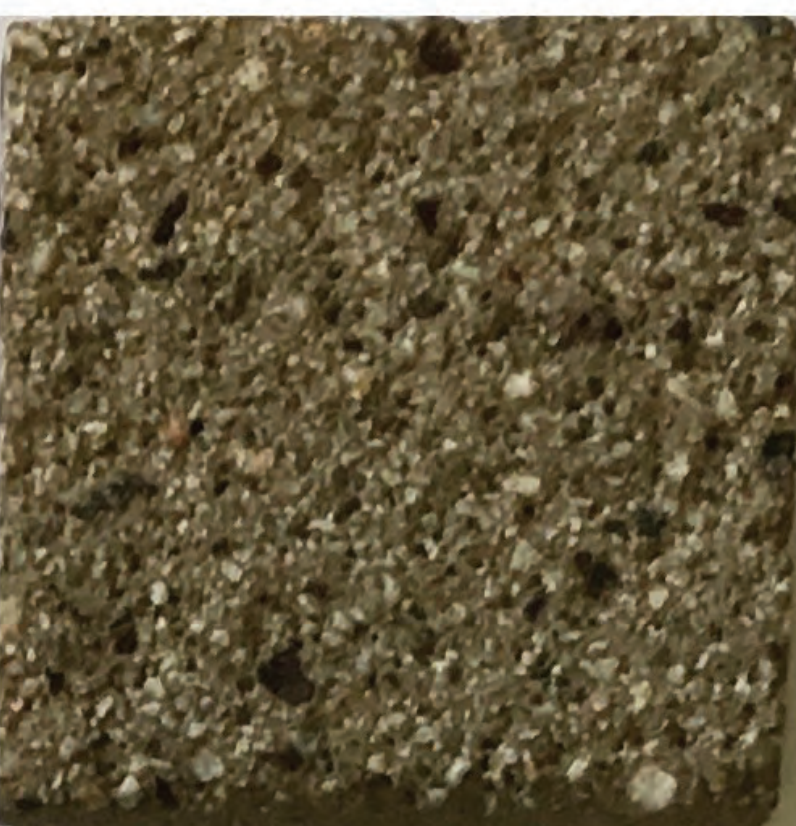

MATERIAL #5

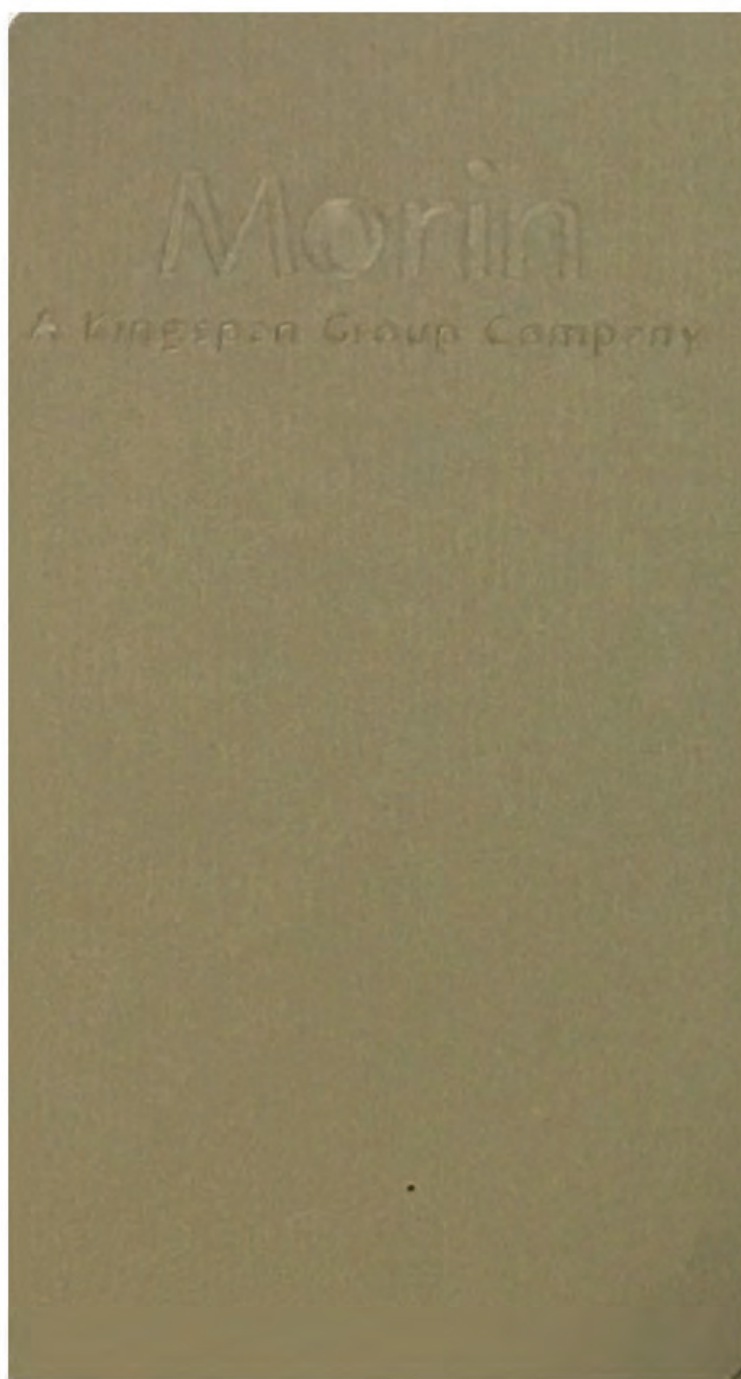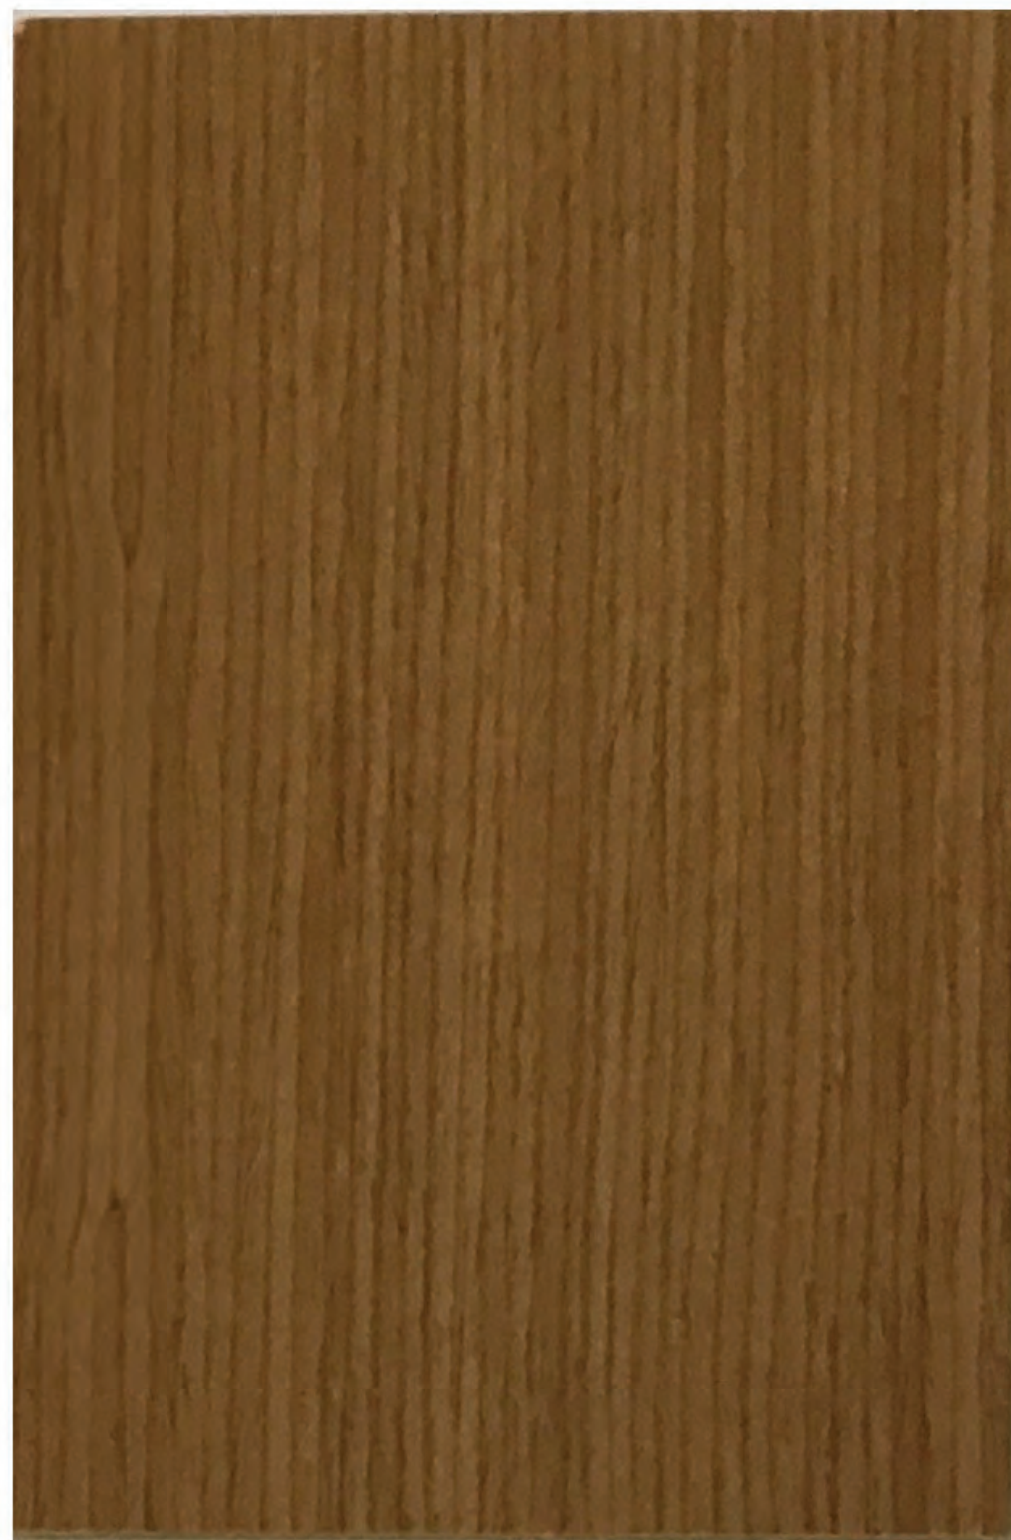

MATERIAL #6

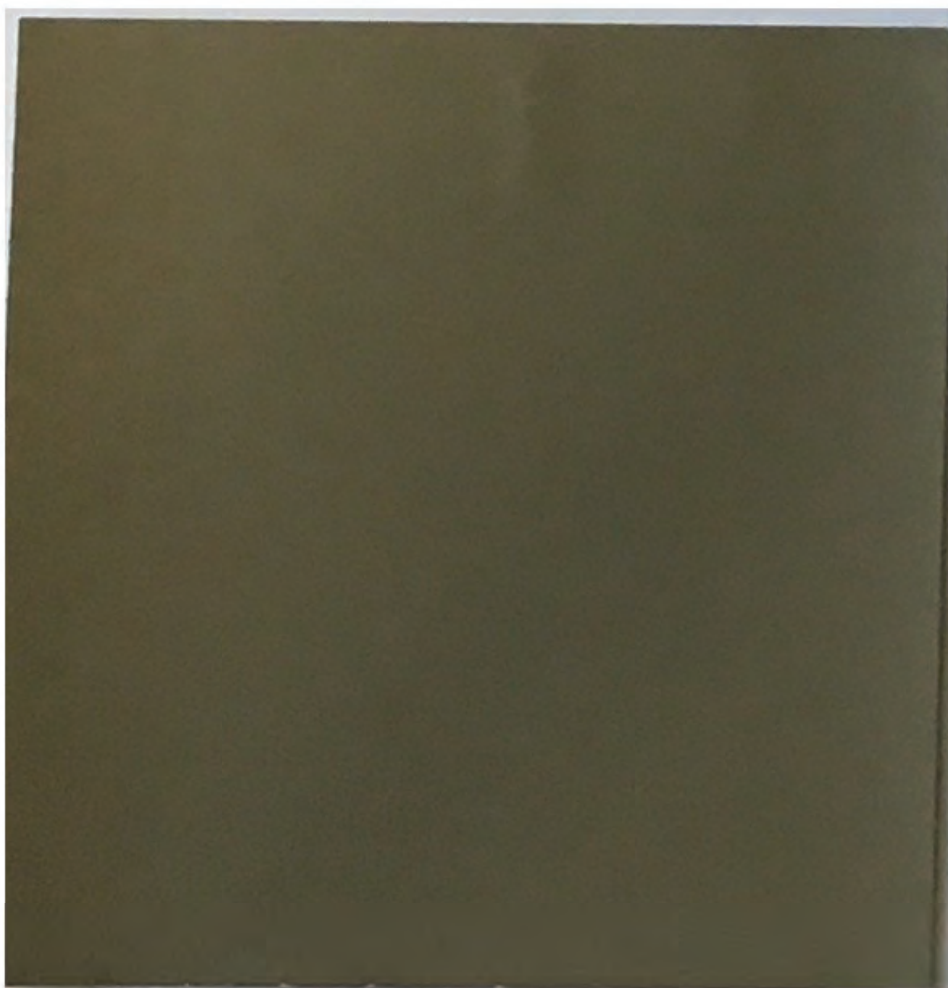

MATERIAL #7



MATERIAL #8



MATERIAL #9

SHEET KEYNOTES

- 1 MATERIAL #1: ROOF MEMBRANE
- 2 MATERIAL #2: STANDING SEAM METAL ROOF
- 3 MATERIAL #3: CMU BLOCK 1
- 4 MATERIAL #4: CMU BLOCK 2
- 5 MATERIAL #5: DECORATIVE/STRUCTURAL WOOD
- 6 MATERIAL #6: SCREEN WALL
- 7 MATERIAL #7: TILTED PLASTER WALL
- 8 MATERIAL #8: WINDOW/STOREFRONT MULLIONS
- 9 MATERIAL #9: GLAZING

